



NOTES
 CONTRACTOR TO CHECK ALL DIMENSIONS ON SITE
 DO NOT SCALE

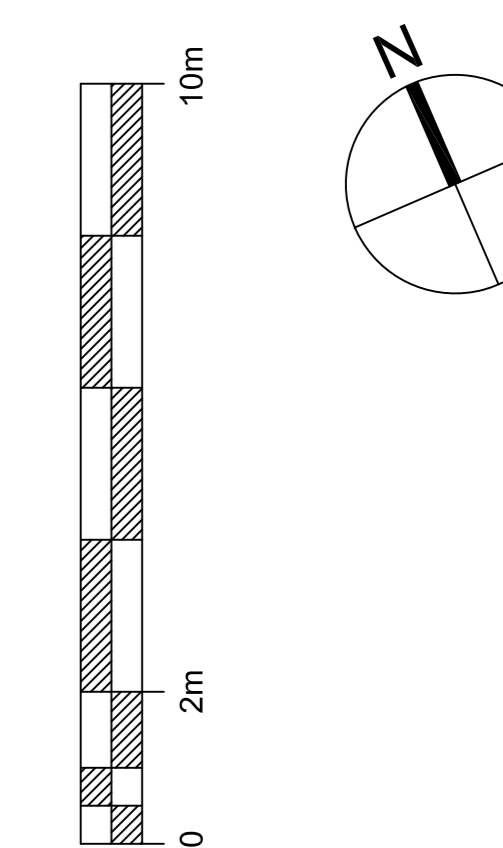

Rev	Description	Date	Drwn
A	Door added, SW Plant Room	1.11.13	JT

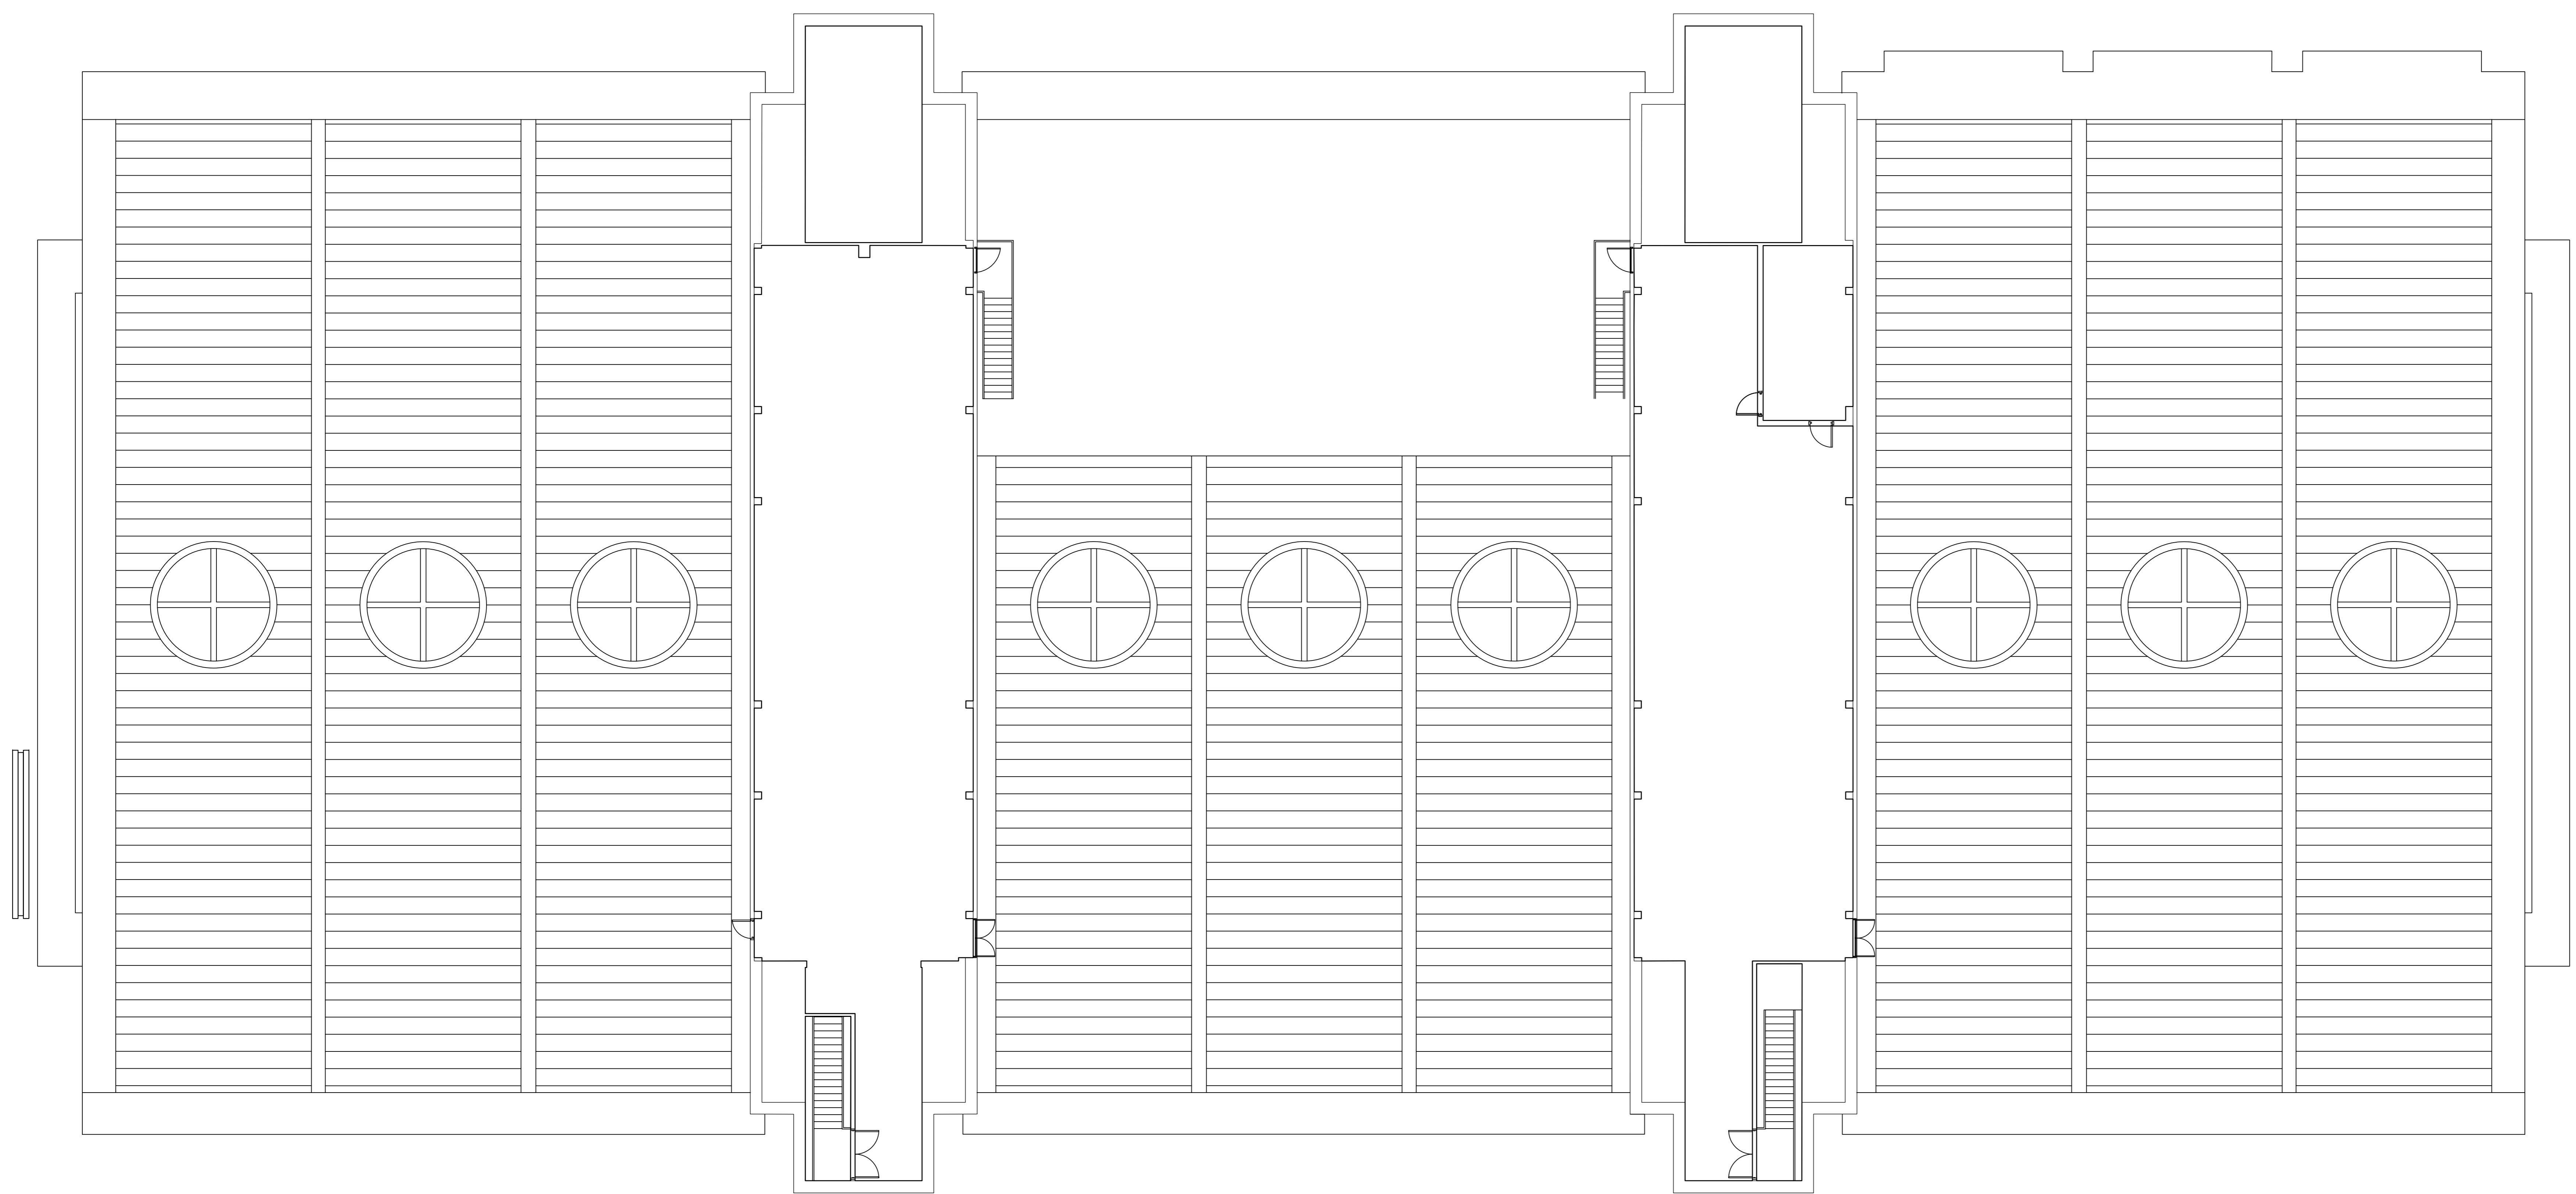

ESTATES AND
 COMMERCIAL FACILITIES

BRAYFORD POOL
 UNIVERSITY OF
 LINCOLN
 LINCOLN, LN6 7TS
 TEL: 01522 886749 FAX: 01522 886247

PRN No. **BR-001**

PROJECT **Minerva Building Master**

PROJECT No. **N/A**

DWG TITLE **Plant Room Floor Plan**

DWG No. **1040** REV *****

DRWN BY **JB** CHECKED BY

SCALE A0@ **1:100** DATE **01.09.14**

1040 Plant Room Floor Plan
 1:100 @ A0