
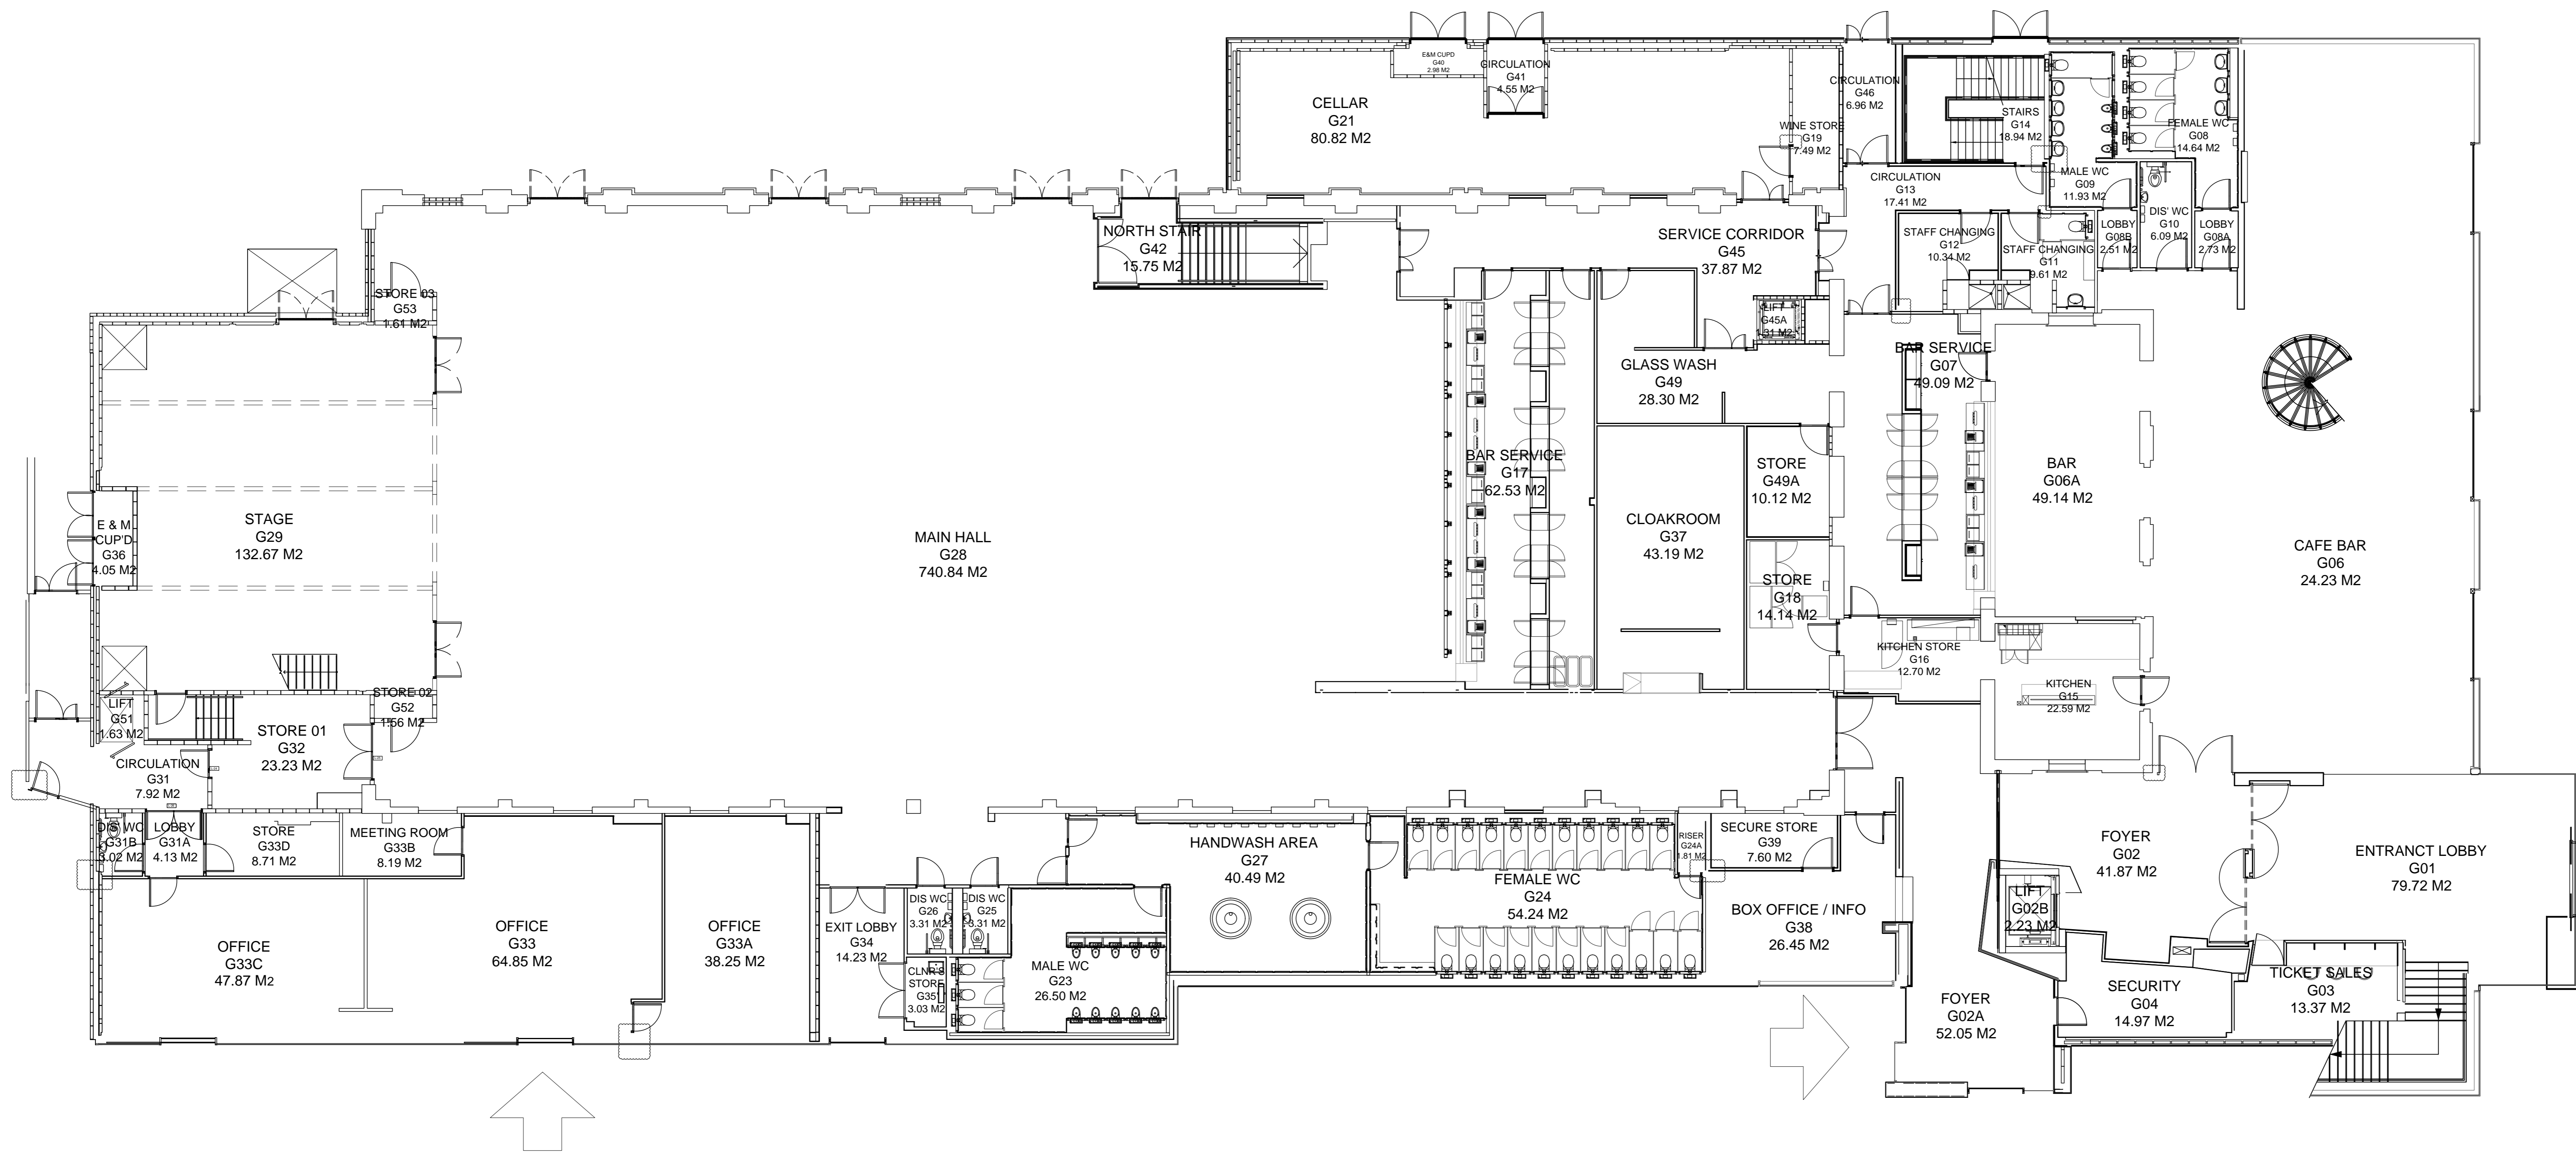
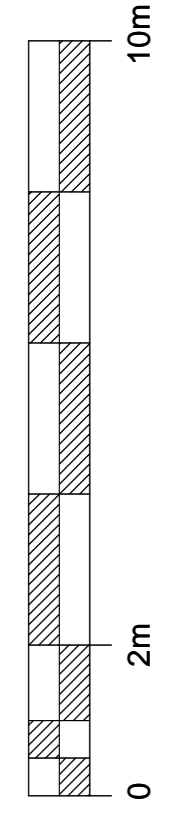


NOTES
CONTRACTOR TO CHECK ALL DIMENSIONS ON SITE
DO NOT SCALE

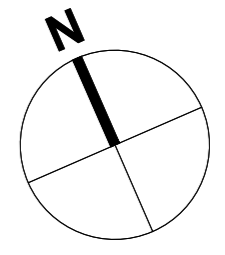

1000

Ground Floor Plan
1:200 @ A1

Rev	Description	Date	Drawn

ESTATES AND COMMERCIAL FACILITIES
BRAYFORD POOL
LINCOLN LN6 7TS
UNIVERSITY OF LINCOLN
TEL: 01522 880749 FAX: 01522 880747

PRJ No. BR-005
PROJECT Students' Union Archive
PROJECT No. N/A
DWG TITLE Ground Floor Plan
DWG No. 1000
REV *

DRWN BY JB CHECKED BY
SCALE A0@ 1:100 DATE 01.09.14