
 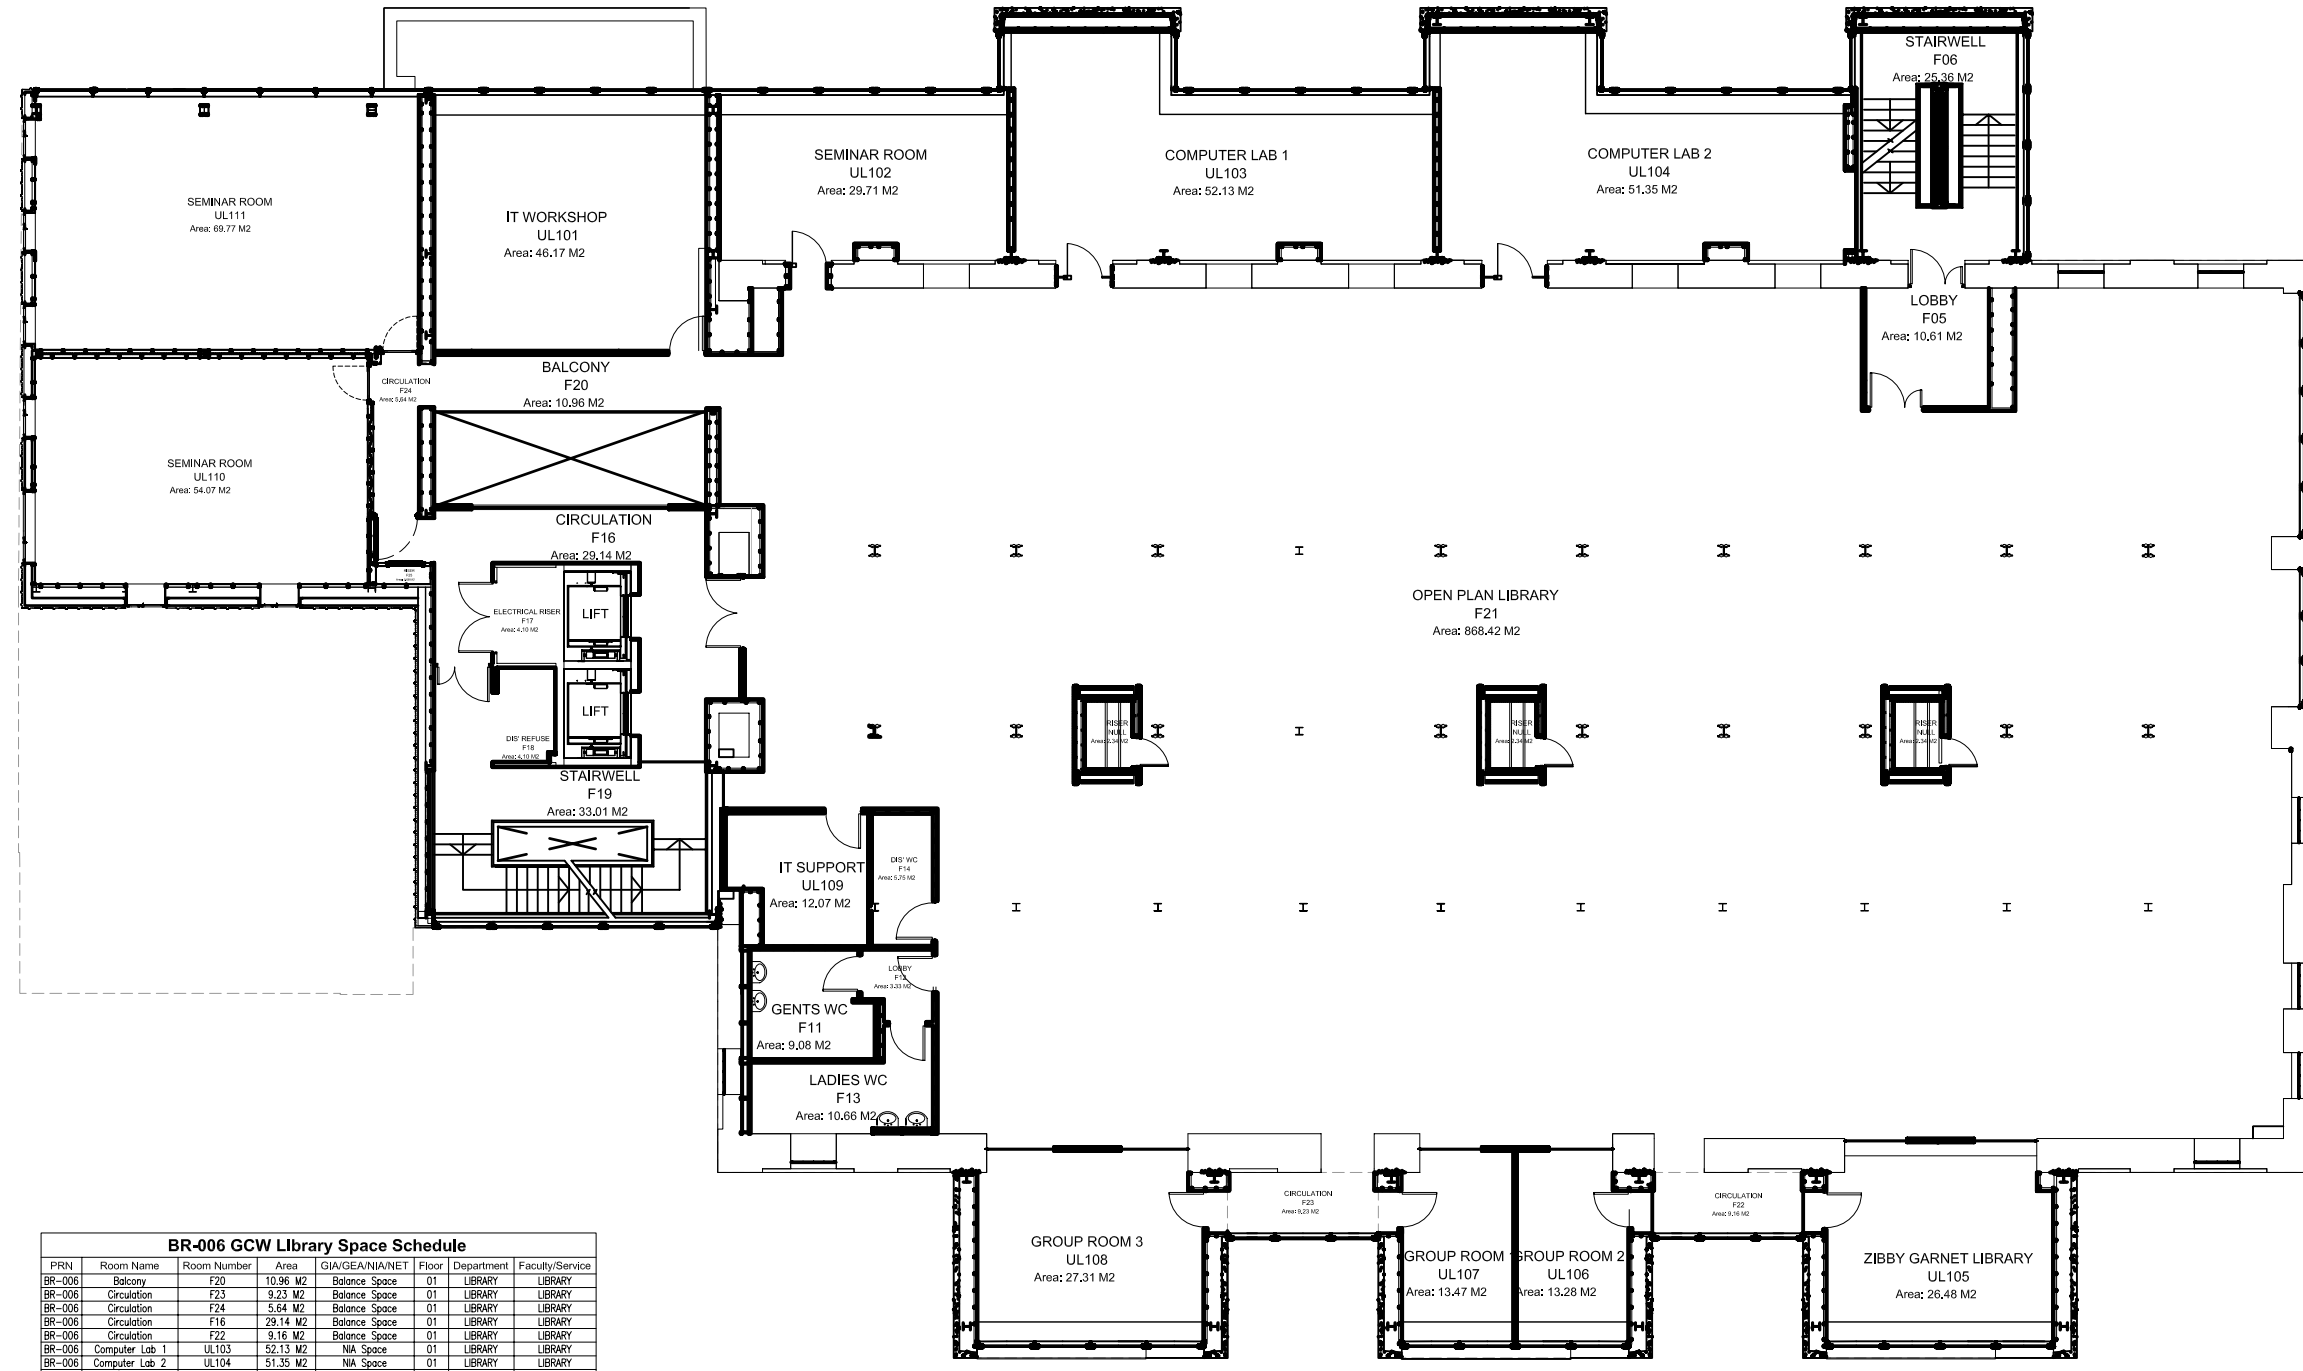



NOTES
 CONTRACTOR TO CHECK ALL DIMENSIONS ON SITE
 DO NOT SCALE

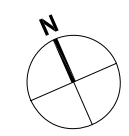

BR-006 GCW Library Space Schedule

PRN	Room Name	Room Number	Area	GIA/GEA/NA/NET	Floor	Department	Faculty/Service
BR-006	Balcony	F20	10.96 M2	Balance Space	01	LIBRARY	LIBRARY
BR-006	Circulation	F23	9.23 M2	Balance Space	01	LIBRARY	LIBRARY
BR-006	Circulation	F24	5.54 M2	Balance Space	01	LIBRARY	LIBRARY
BR-006	Circulation	F16	29.14 M2	Balance Space	01	LIBRARY	LIBRARY
BR-006	Circulation	F22	9.16 M2	Balance Space	01	LIBRARY	LIBRARY
BR-006	Computer Lab 1	UL103	52.13 M2	NA Space	01	LIBRARY	LIBRARY
BR-006	Computer Lab 2	UL104	51.35 M2	NA Space	01	LIBRARY	LIBRARY
BR-006	Dis. Refuse	F18	4.10 M2	Balance Space	01	LIBRARY	LIBRARY
BR-006	Dis. WC	F14	5.75 M2	Balance Space	01	LIBRARY	LIBRARY
BR-006	Electrical Riser	F17	4.10 M2	Balance Space	01	LIBRARY	LIBRARY
BR-006	GEA	--	1690.49 M2	GEA Space	01	LIBRARY	LIBRARY
BR-006	Gents WC	F11	9.08 M2	Balance Space	01	LIBRARY	LIBRARY
BR-006	Group Room 1	UL107	13.47 M2	NA Space	01	LIBRARY	LIBRARY
BR-006	Group Room 2	UL106	13.28 M2	NA Space	01	LIBRARY	LIBRARY
BR-006	Group Room 3	UL108	27.31 M2	NA Space	01	LIBRARY	LIBRARY
BR-006	IT Support	UL109	12.07 M2	NA Space	01	LIBRARY	LIBRARY
BR-006	IT Workshop	UL101	46.17 M2	NA Space	01	LIBRARY	LIBRARY
BR-006	Ladies WC	F13	10.66 M2	Balance Space	01	LIBRARY	LIBRARY
BR-006	Lobby	F05	10.61 M2	Balance Space	01	LIBRARY	LIBRARY
BR-006	Lobby	F12	3.33 M2	Balance Space	01	LIBRARY	LIBRARY
BR-006	Open Plan Library	F21	868.42 M2	NA Space	01	LIBRARY	LIBRARY
BR-006	Riser	NULL	2.34 M2	Balance Space	01	LIBRARY	LIBRARY
BR-006	Riser	NULL	2.34 M2	Balance Space	01	LIBRARY	LIBRARY
BR-006	Riser	NULL	2.34 M2	Balance Space	01	LIBRARY	LIBRARY
BR-006	Riser	F25	0.68 M2	Balance Space	01	LIBRARY	LIBRARY
BR-006	Seminar Room	UL102	29.71 M2	NA Space	01	LIBRARY	LIBRARY
BR-006	Seminar Room	UL110	54.07 M2	NA Space	01	LIBRARY	LIBRARY
BR-006	Seminar Room	UL111	69.77 M2	NA Space	01	LIBRARY	LIBRARY
BR-006	Stairwell	F19	33.01 M2	Balance Space	01	LIBRARY	LIBRARY
BR-006	Stairwell	F06	25.36 M2	Balance Space	01	LIBRARY	LIBRARY
BR-006	Zibby Garnet Library	UL105	26.48 M2	NA Space	01	LIBRARY	LIBRARY

1010 First Floor Plan
 1:200 @ A3

Rev	Description	Date	Drawn



PRN No.	BR-006
PROJECT	University Library Archive
PROJECT No.	N/A
DWG TITLE	First Floor Plan
DWG No.	1010
REV	*
DRWN BY	JB
CHECKED BY	
SCALE	A1 @ 1:100
DATE	23.09.13