 



NOTES
 CONTRACTOR TO CHECK ALL DIMENSIONS ON SITE
 DO NOT SCALE

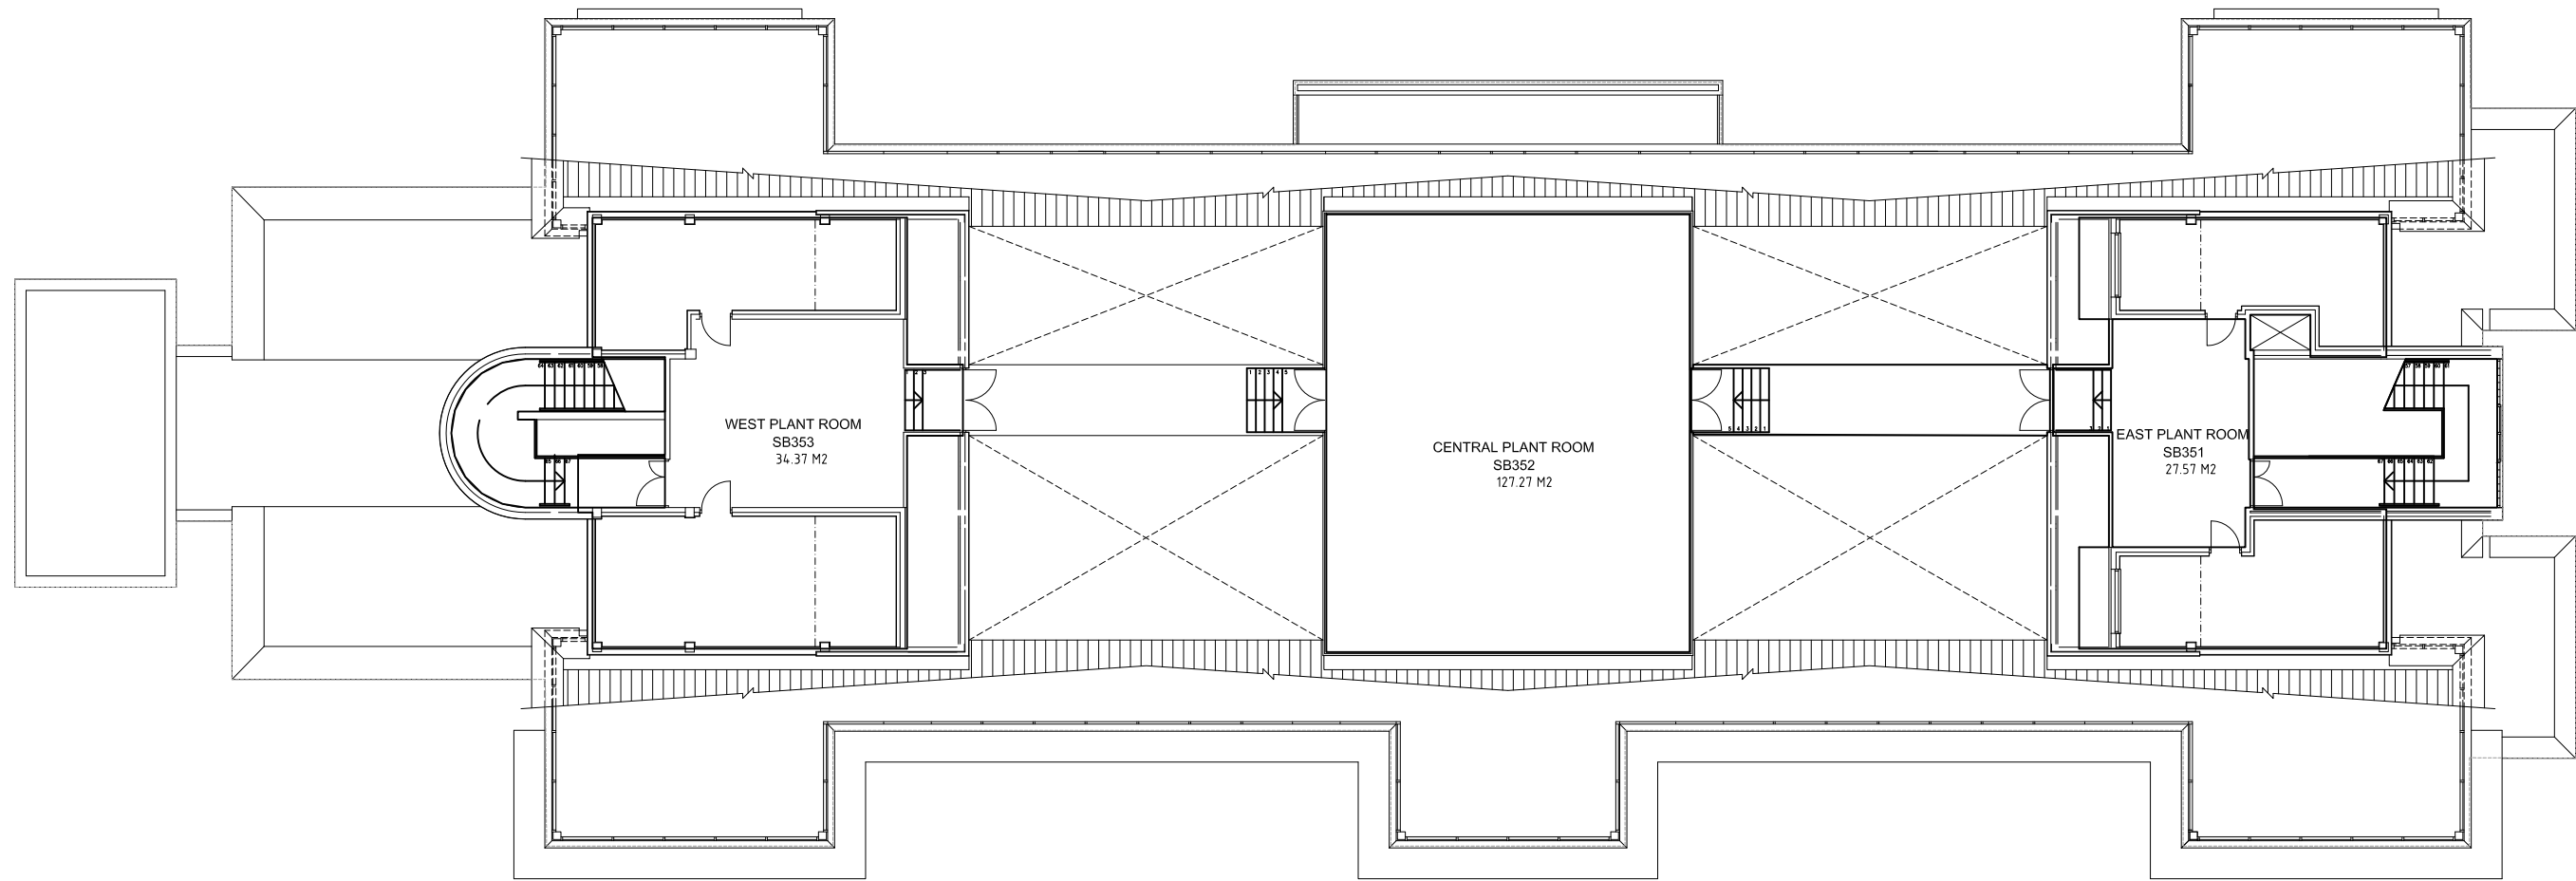

BR-009 Science Building Room Schedule

PRN	Room Name	Room Number	Area	GIA/GEA/NIA/NET	Floor	Department	Faculty/Service
BR-007	Central plant room	SB352	127.27 M2	Balance Space	03	--	--
BR-007	East plant room	SB351	27.57 M2	Balance Space	03	--	--
BR-007	GEA Space	--	314.74 M2	GEA Space	03	--	--
BR-007	GIA Space	--	34.37 M2	GIA Space	03	--	--
BR-007	GIA Space	--	127.27 M2	GIA Space	03	--	--
BR-007	GIA Space	--	27.57 M2	GIA Space	03	--	--
BR-007	West plant room	SB353	34.37 M2	Balance Space	03	--	--

Rev	Description	Date	Dwn

ESTATES AND FACILITIES
 SERVICE BUILDING
 BRAYFORD POOL
 LINCOLN, LN6 7TS
 UNIVERSITY OF LINCOLN
 TEL: 01522 886749 FAX: 01522 886247

PRN. No. **BR-007**
 PROJECT. **Science Building Archive**
 PROJECT No. **000**
 DWG TITLE. **Roof Plan**
 DWG No. **1030** REV *****
 DRWN BY. **JB** CHECKED BY.
 SCALE. **A1 @ 1:100** DATE **17.12.12**

1030
 Roof Plan
 1:200 @ A3