



BR-027 Court 10 Room Schedule

PRN	Room Name	Room Number	Area	GIA/GEA/NIA/NET	Floor	Department	Faculty/Service
BR-027	Circulation	10.7.52	2.06 M2	Balance Space	03	--	--
BR-027	Circulation	10.7.56	11.83 M2	Balance Space	03	--	--
BR-027	GEA Space	--	141.75 M2	GEA Space	03	--	--
BR-027	GIA Space	--	127.56 M2	GIA Space	03	--	--
BR-027	Kitchen	10.7.60	21.99 M2	NIA Space	03	--	--
BR-027	Lobby	10.7.51	3.56 M2	Balance Space	03	--	--
BR-027	Riser	10.7.59	0.40 M2	Balance Space	03	--	--
BR-027	Riser	10.7.57	0.52 M2	Balance Space	03	--	--
BR-027	Riser	10.7.58	0.17 M2	Balance Space	03	--	--
BR-027	Riser	10.7.55	0.17 M2	Balance Space	03	--	--
BR-027	Riser	10.7.54	0.37 M2	Balance Space	03	--	--
BR-027	Stair	10.7.50	10.54 M2	Balance Space	03	--	--
BR-026	Store	10.7.61	1.97 M2	NIA Space	03	--	--

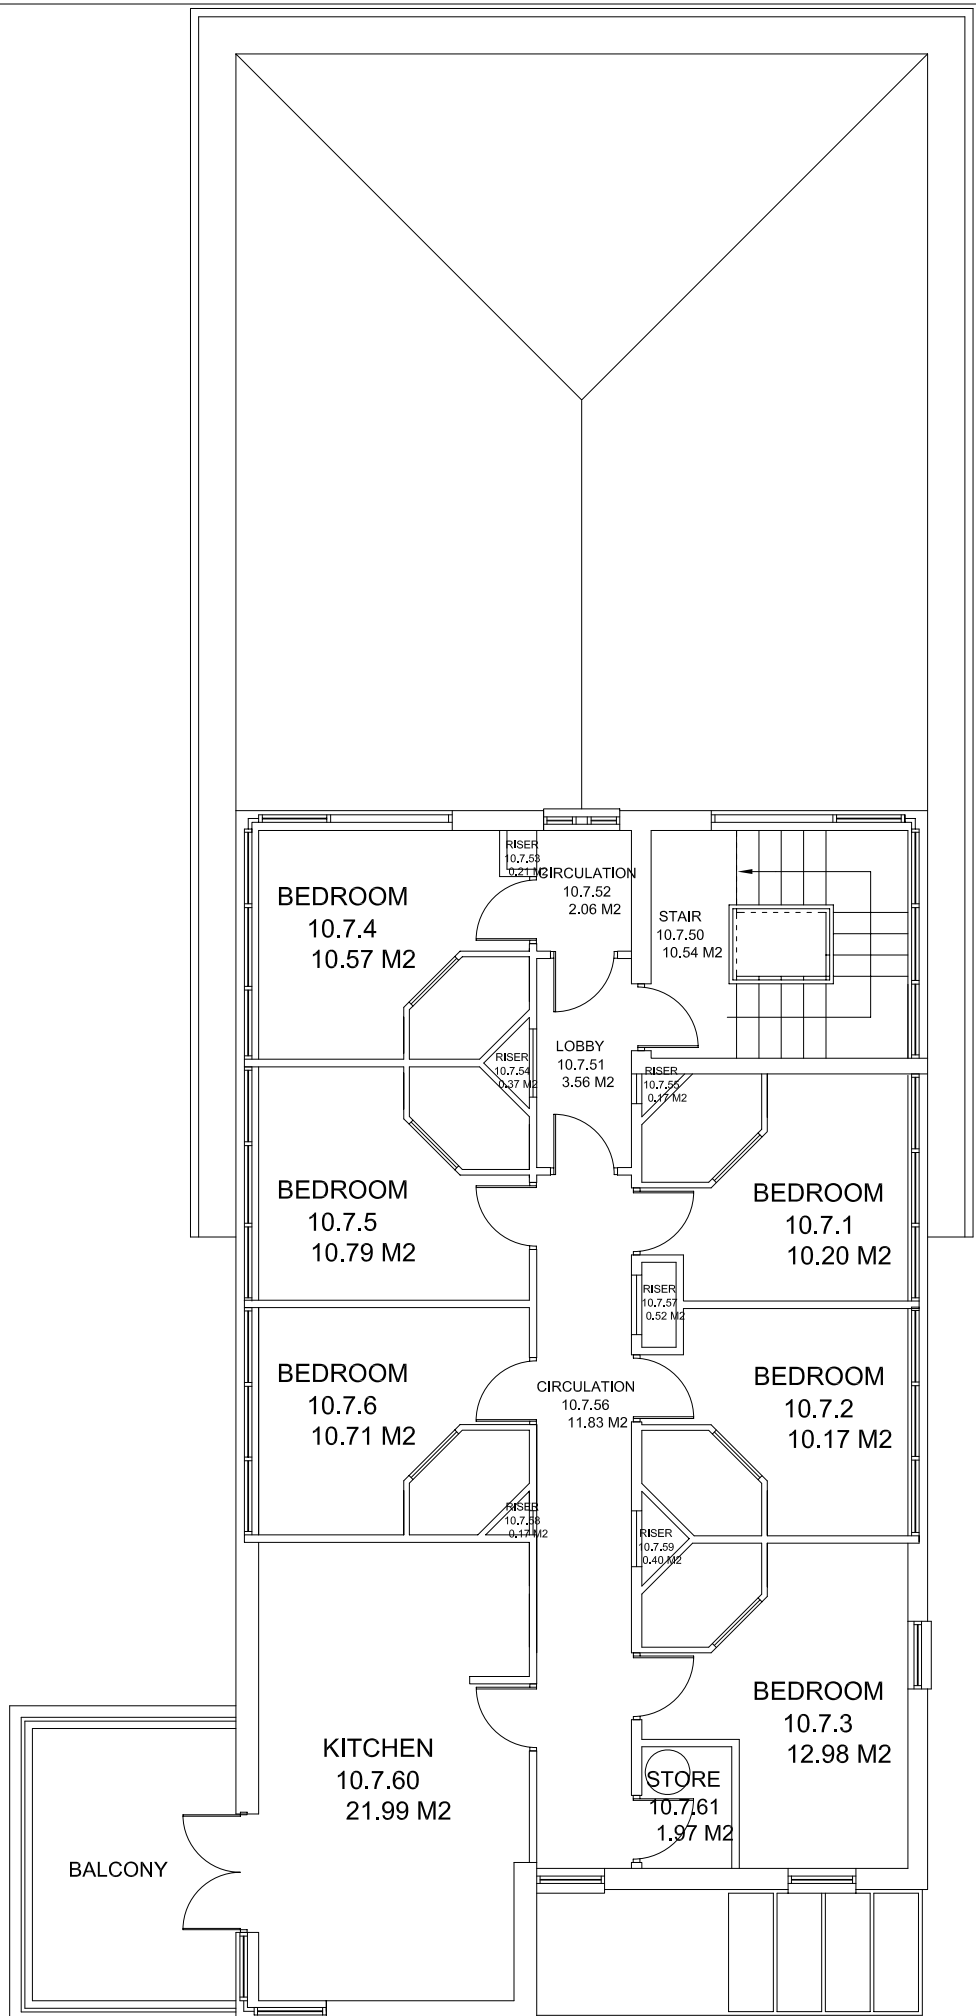

NOTES
CONTRACTOR TO CHECK ALL DIMENSIONS ON SITE
DO NOT SCALE

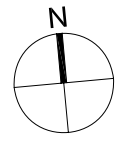

Rev	Description	Date	Drawn

ESTATES AND FACILITIES
SERVICE BUILDING
BRAYFORD POOL
LINCOLN LN6 7TS
TEL: 01522 886749 FAX: 01522 886247

PRN No. **BR-027**

PROJECT **Court 10 Archive**

PROJECT No. **N/A**

DWG TITLE **Third Floor Plan**

DWG No. **1030** REV *****

DRWN BY **JB** CHECKED BY

SCALE A1 @ **1:50** DATE **28/06/11**