
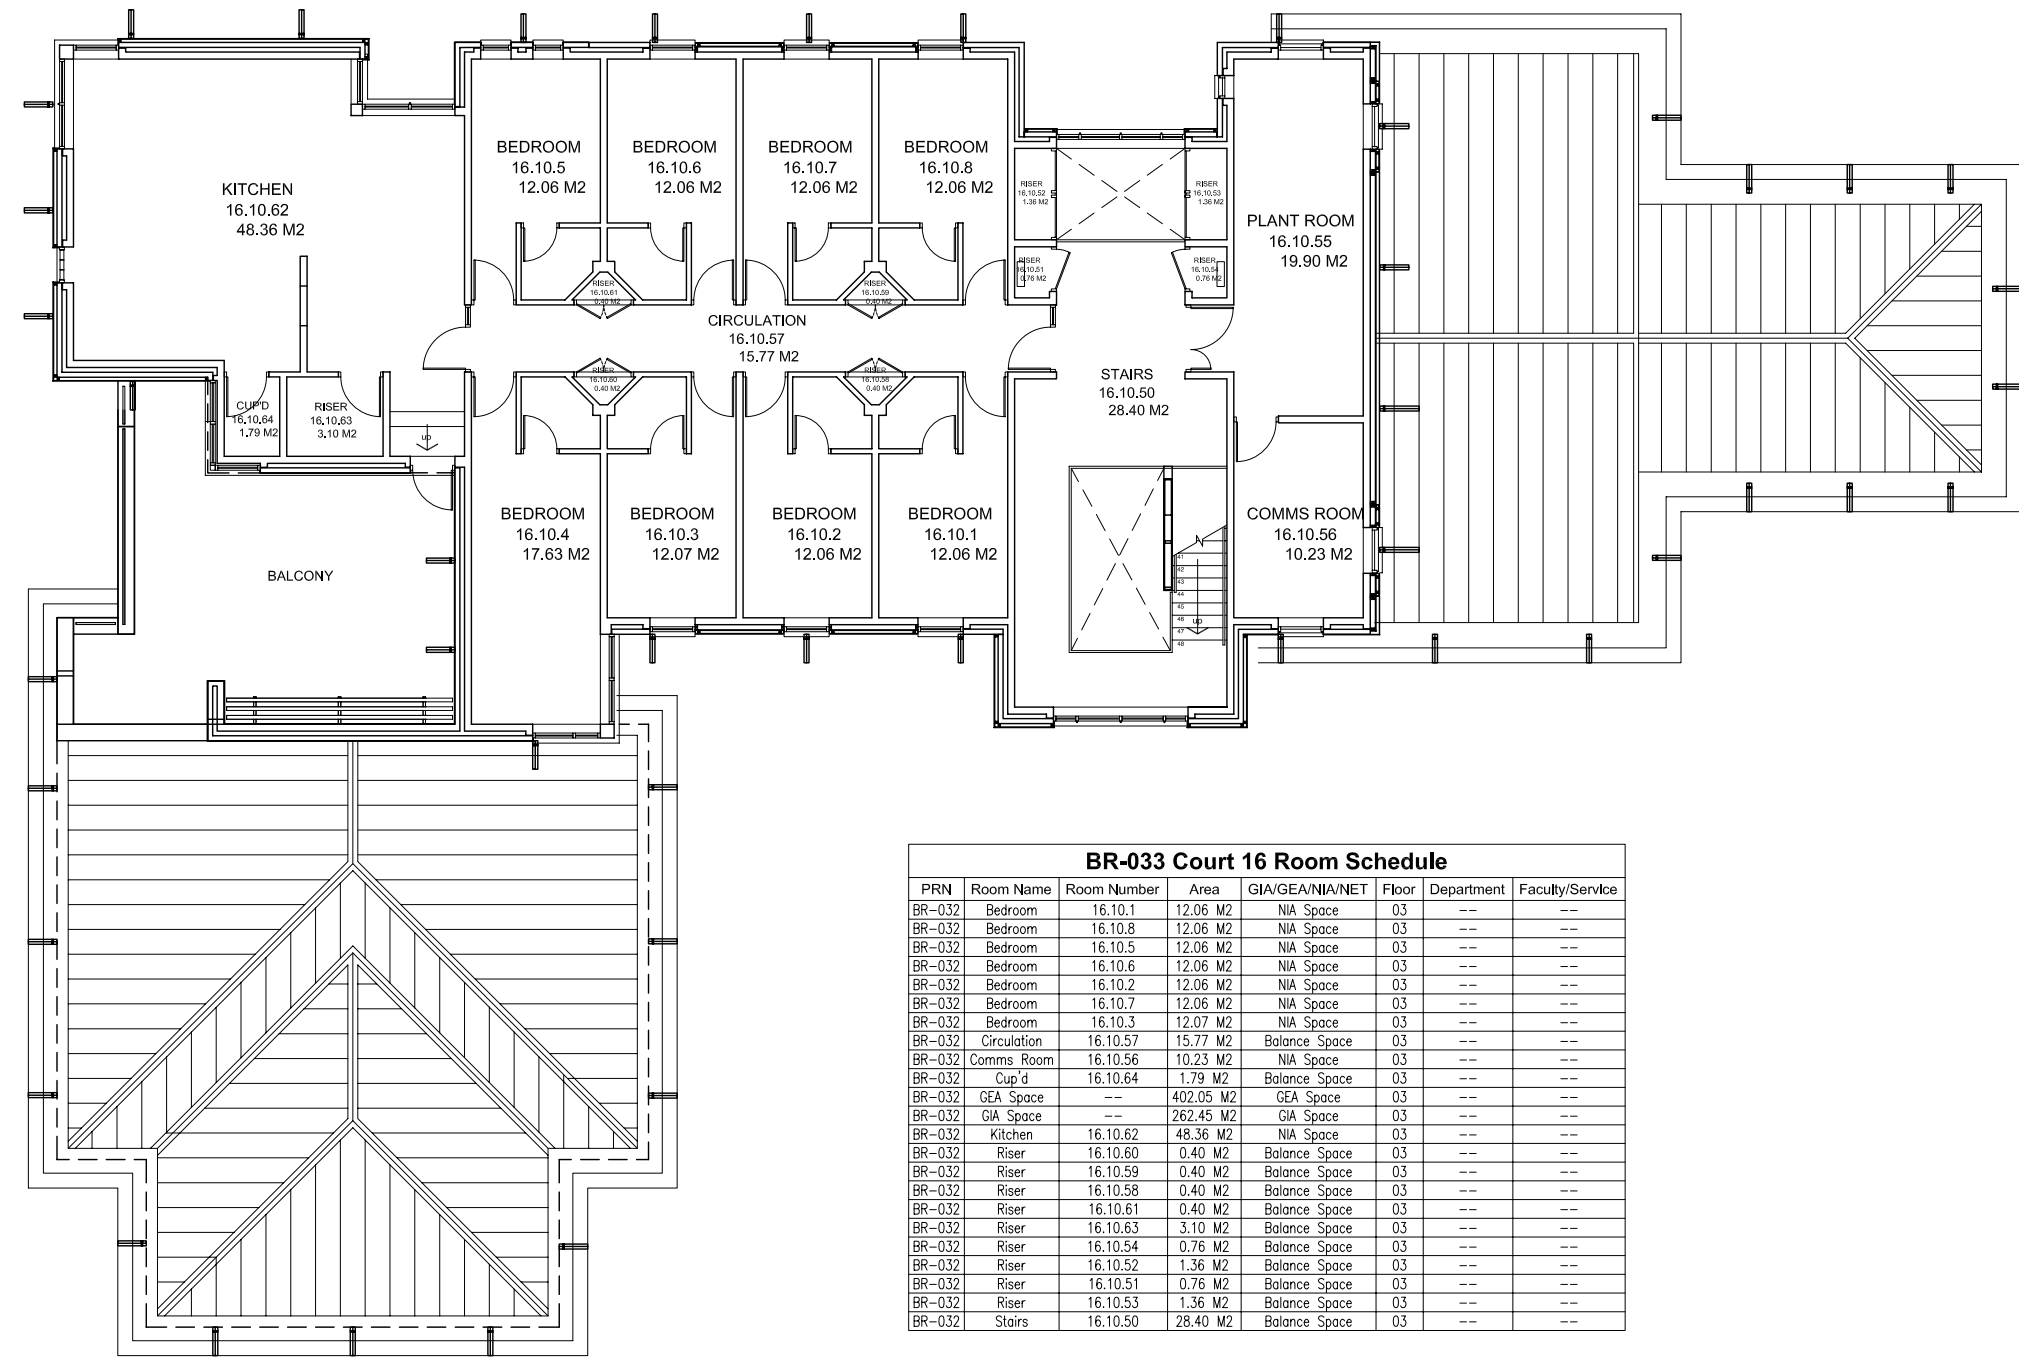


NOTES  
 CONTRACTOR TO CHECK ALL DIMENSIONS ON SITE  
 DO NOT SCALE

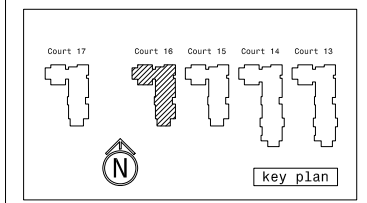


**BR-033 Court 16 Room Schedule**

PRN	Room Name	Room Number	Area	GIA/GEA/NIA/NET	Floor	Department	Faculty/Service
BR-032	Bedroom	16.10.1	12.06 M2	NIA Space	03	--	--
BR-032	Bedroom	16.10.8	12.06 M2	NIA Space	03	--	--
BR-032	Bedroom	16.10.5	12.06 M2	NIA Space	03	--	--
BR-032	Bedroom	16.10.6	12.06 M2	NIA Space	03	--	--
BR-032	Bedroom	16.10.2	12.06 M2	NIA Space	03	--	--
BR-032	Bedroom	16.10.7	12.06 M2	NIA Space	03	--	--
BR-032	Bedroom	16.10.3	12.07 M2	NIA Space	03	--	--
BR-032	Circulation	16.10.57	15.77 M2	Balance Space	03	--	--
BR-032	Comms Room	16.10.56	10.23 M2	NIA Space	03	--	--
BR-032	Cup'd	16.10.64	1.79 M2	Balance Space	03	--	--
BR-032	GEA Space	--	402.05 M2	GEA Space	03	--	--
BR-032	GIA Space	--	262.45 M2	GIA Space	03	--	--
BR-032	Kitchen	16.10.62	48.36 M2	NIA Space	03	--	--
BR-032	Riser	16.10.60	0.40 M2	Balance Space	03	--	--
BR-032	Riser	16.10.59	0.40 M2	Balance Space	03	--	--
BR-032	Riser	16.10.58	0.40 M2	Balance Space	03	--	--
BR-032	Riser	16.10.61	0.40 M2	Balance Space	03	--	--
BR-032	Riser	16.10.63	3.10 M2	Balance Space	03	--	--
BR-032	Riser	16.10.54	0.76 M2	Balance Space	03	--	--
BR-032	Riser	16.10.52	1.36 M2	Balance Space	03	--	--
BR-032	Riser	16.10.51	0.76 M2	Balance Space	03	--	--
BR-032	Riser	16.10.53	1.36 M2	Balance Space	03	--	--
BR-032	Stairs	16.10.50	28.40 M2	Balance Space	03	--	--

1030

Third Floor Plan  
 1:150 @ A3

Rev	Description	Date	Drwn


**ESTATES AND FACILITIES**  
 SERVICE BUILDING  
 BRAYFORD POOL  
 LINCOLN, LN6 7TS  
 TEL: 01522 886749 FAX: 01522 886247

PRN No. **BR-033**  
 PROJECT **Court 16 Archive**  
 PROJECT No. **N/A**  
 DWG TITLE **Third Floor Plan**  
 DWG No. **1030** REV **\***

DRWN BY **JB** CHECKED BY.   
 SCALE **A1 @ 1:75** DATE **23/06/11**