
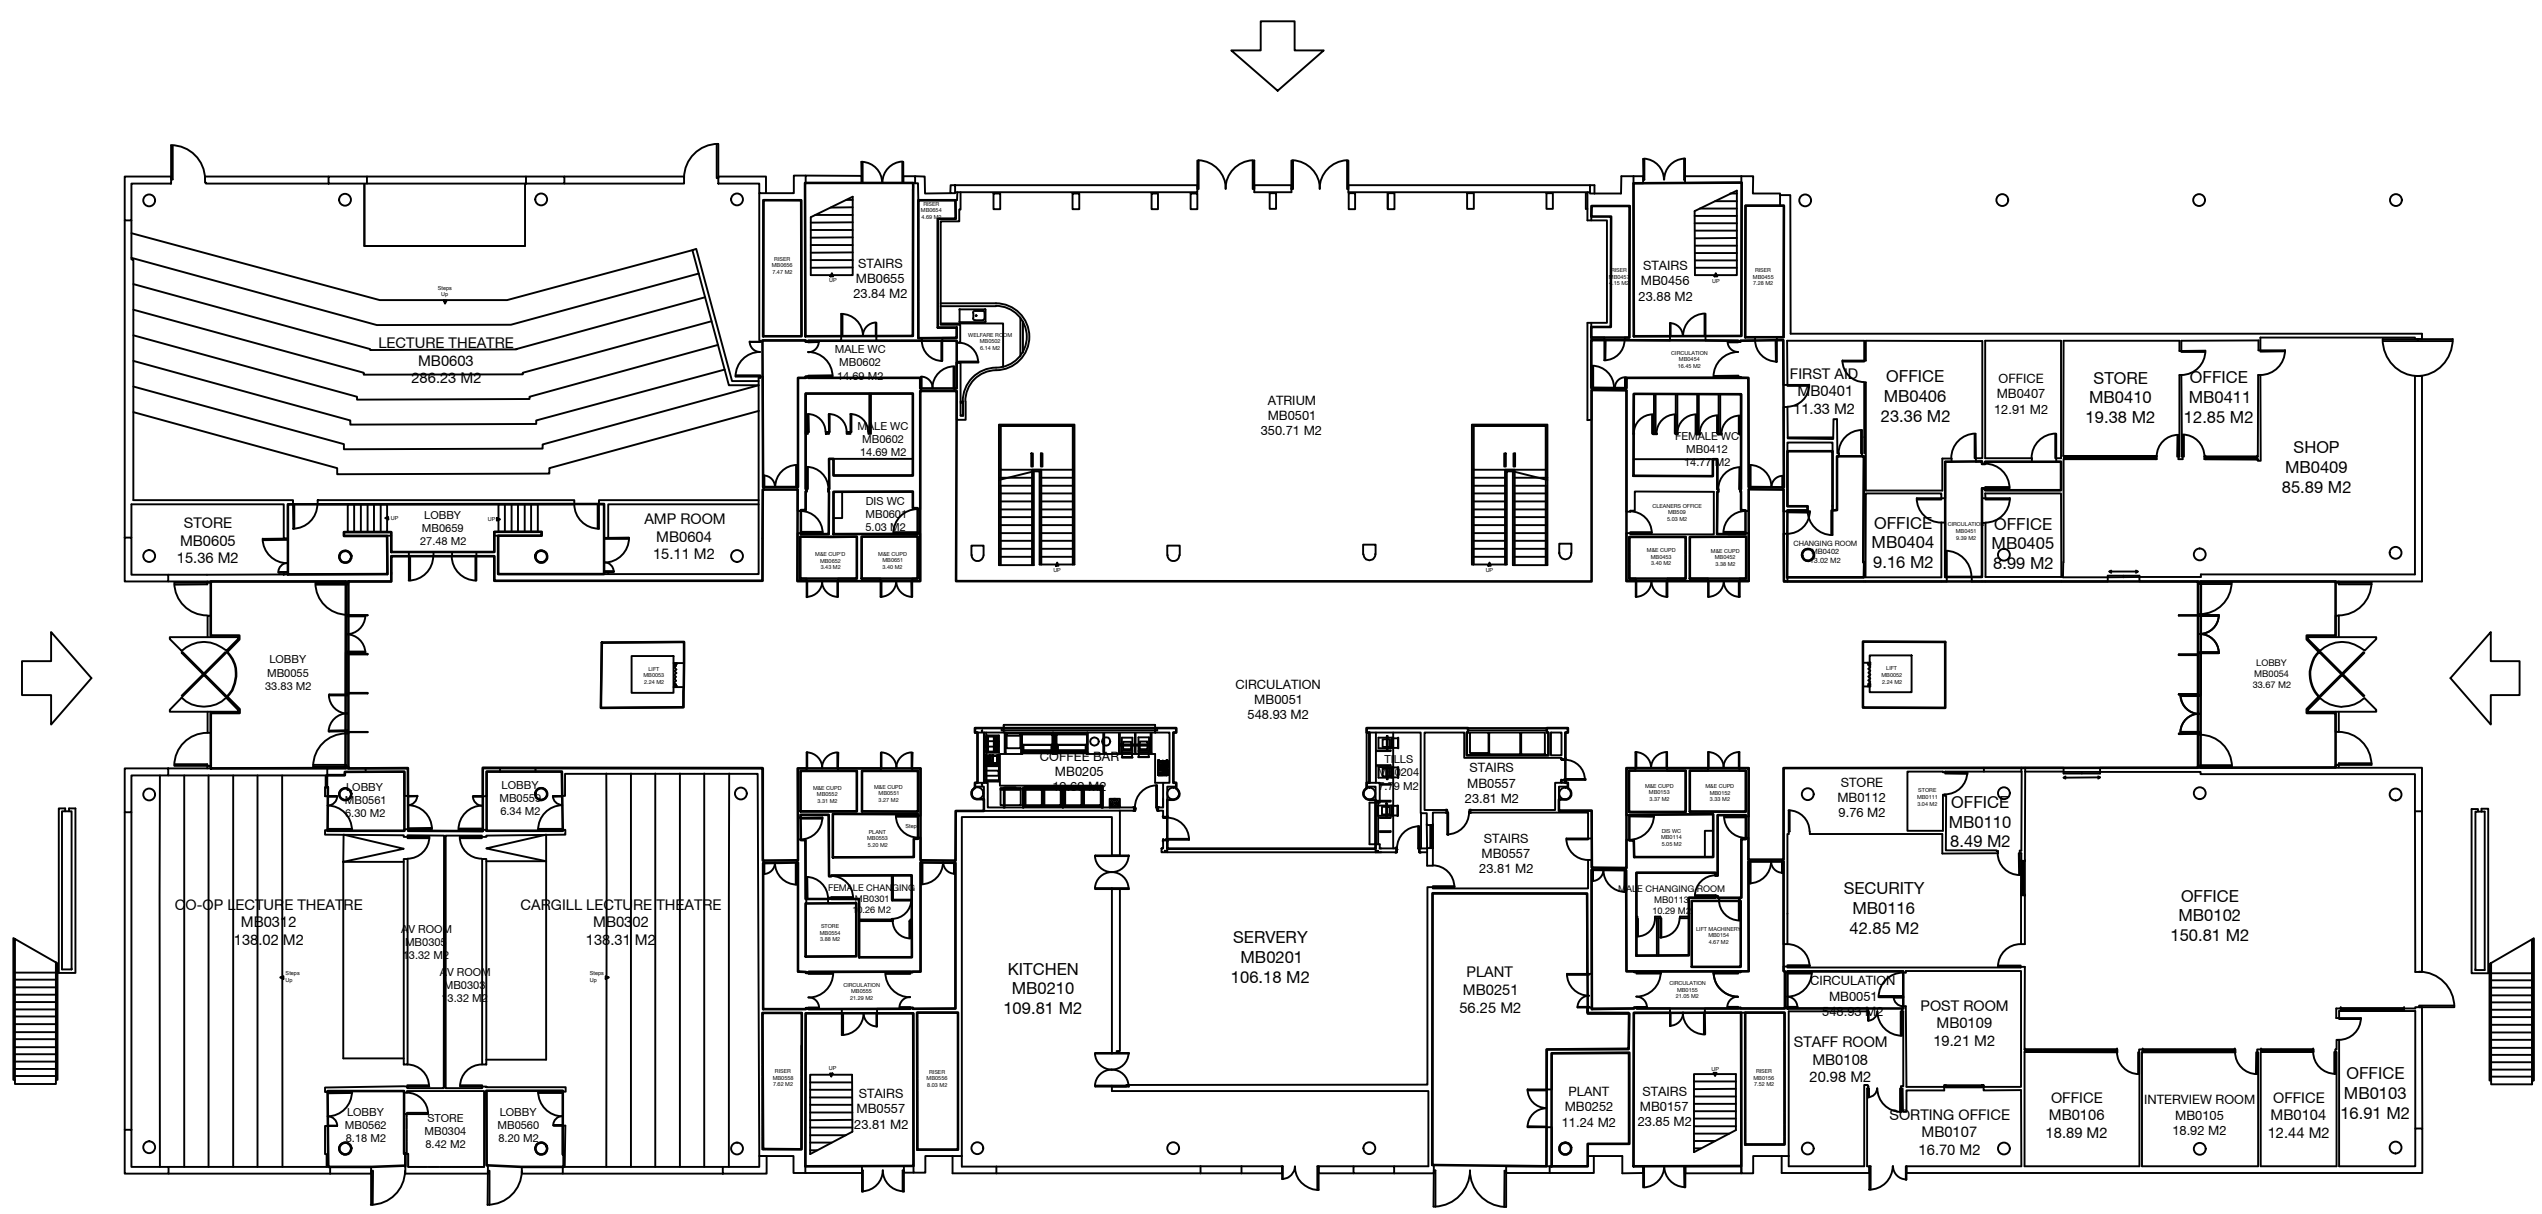


NOTES  
CONTRACTOR TO CHECK ALL DIMENSIONS ON SITE  
DO NOT SCALE

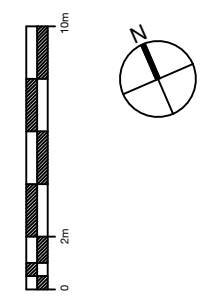

1000 Ground Floor Plan  
1:100 @ A0

Rev	Description	Date	Drawn


**UNIVERSITY OF LINCOLN**  
 ESTATES AND COMMERCIAL FACILITIES  
 BRAYFORD POOL  
 LINCOLN, LN6 9TS  
 TEL: 01522 881160 FAX: 01522 88847

PRN No. BR-001  
 PROJECT Minerva Building Archive  
 PROJECT No. 000  
 DWG TITLE Ground Floor Plan  
 DWG No. 1000 REV \*  
 DRWN BY JT CHECKED BY JB  
 SCALE A0@ 1:100 DATE 10.02.16