
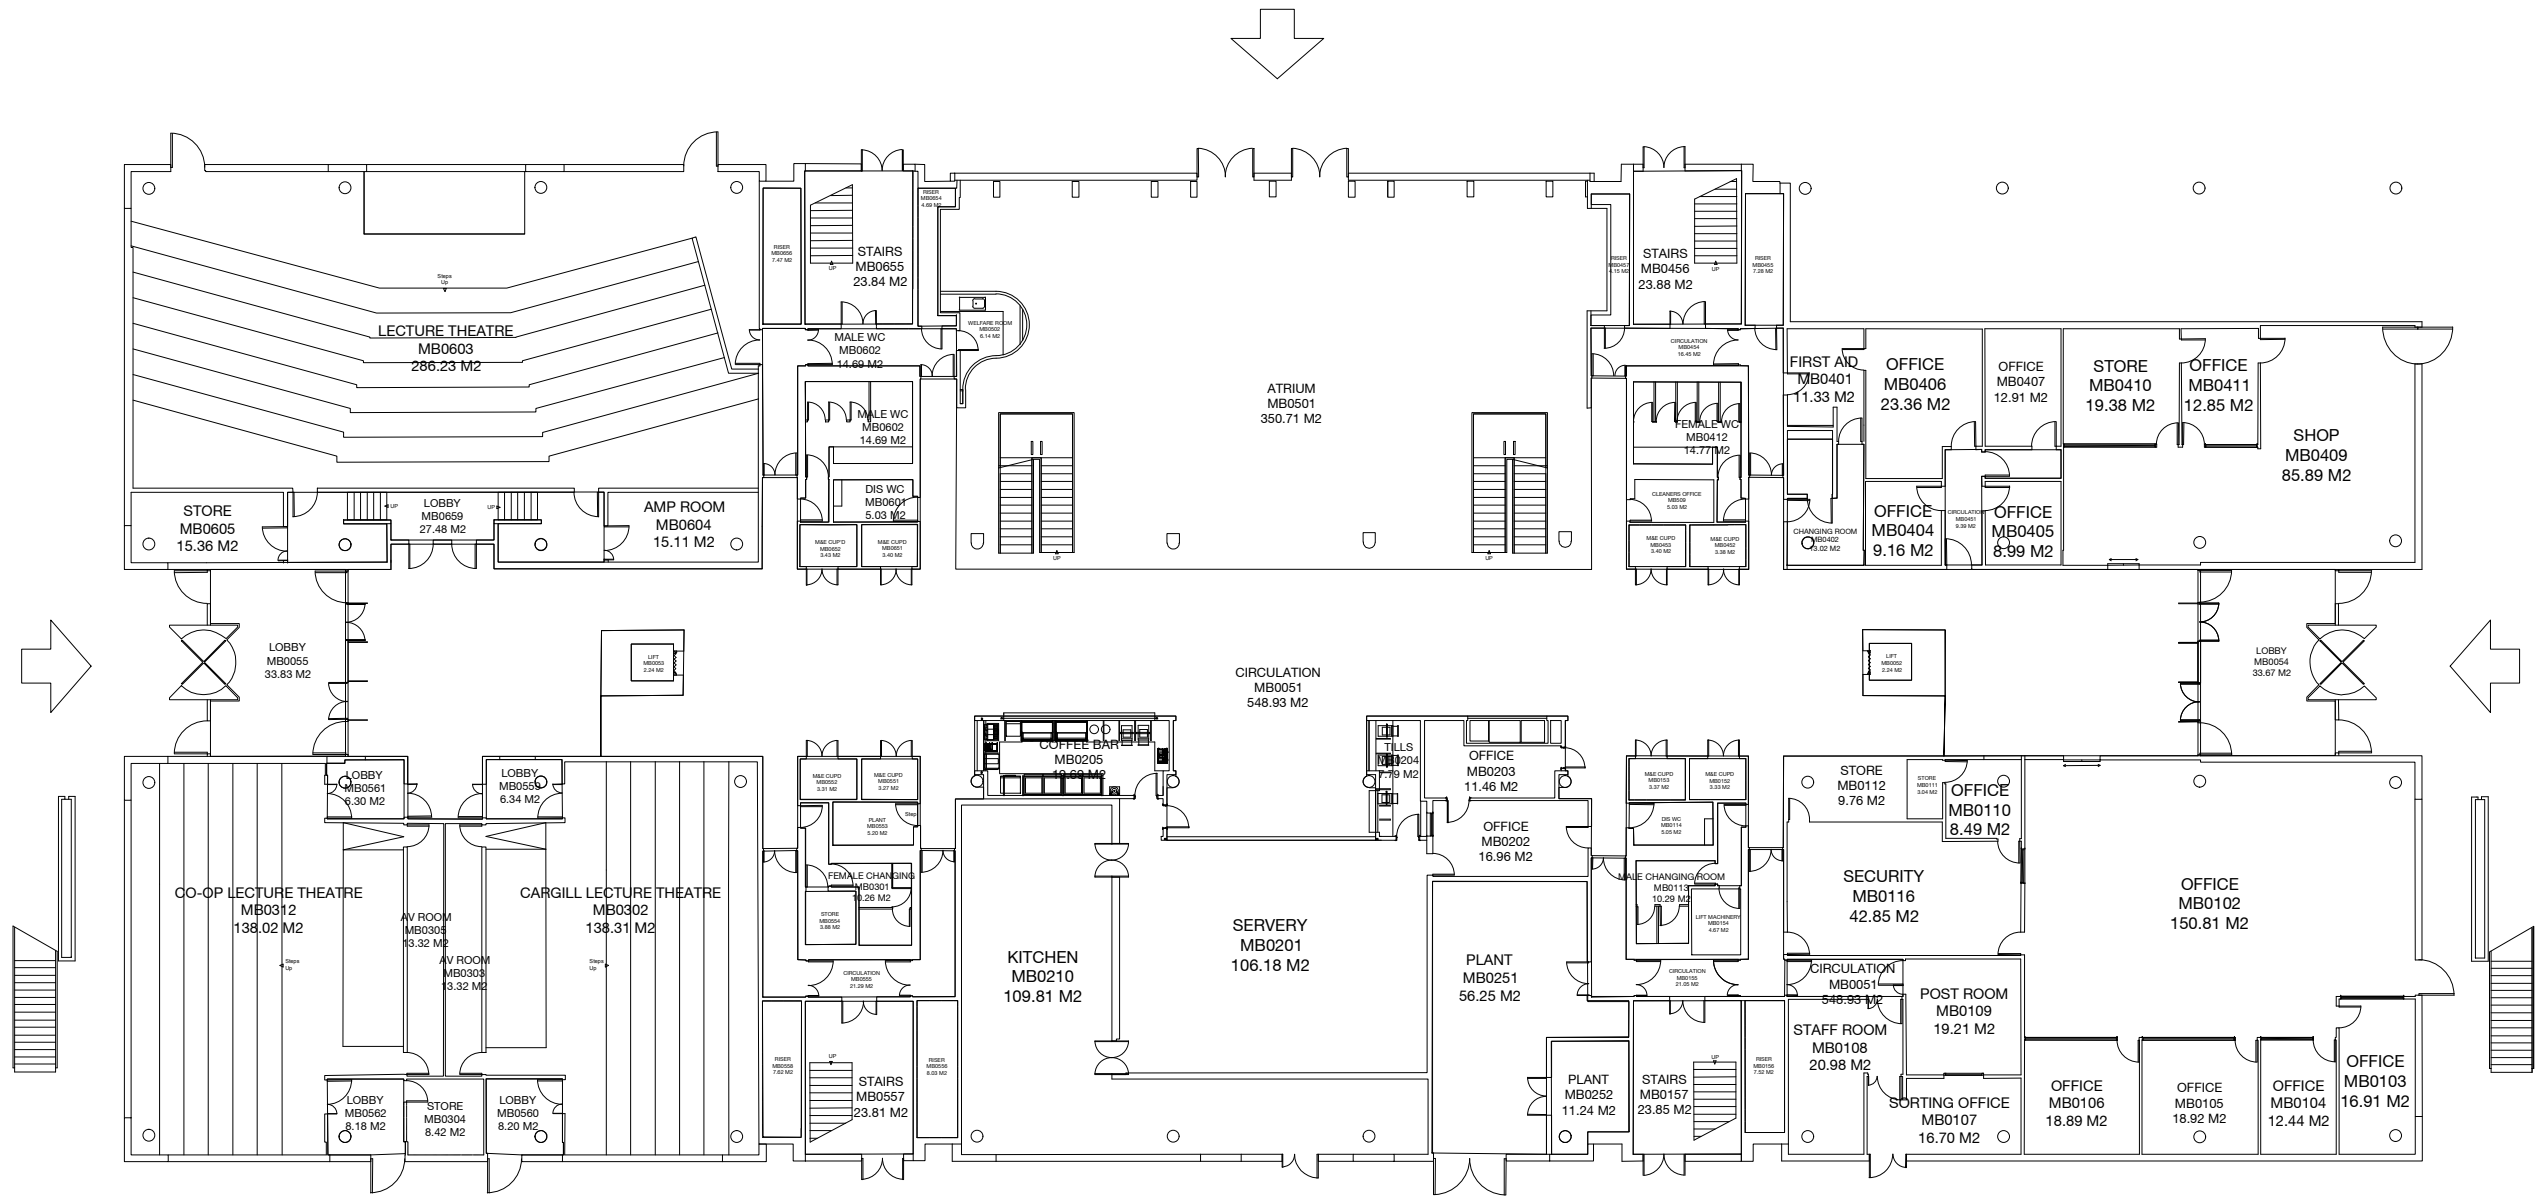



NOTES
CONTRACTOR TO CHECK ALL DIMENSIONS ON SITE
DO NOT SCALE

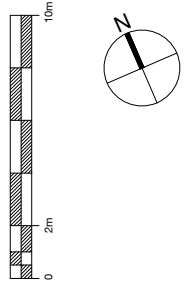

1000
Ground Floor Plan
1:100 @ A0

Rev	Description	Date	Drawn


UNIVERSITY OF LINCOLN
 ESTATES AND COMMERCIAL FACILITIES
 BRAYFORD POOL
 LINCOLN, LN6 9TS
 TEL: 01522 881160 FAX: 01522 888471

PRN No.	BR-001
PROJECT	Minerva Building Archive
PROJECT No.	000
DWG TITLE	Ground Floor Plan
DWG No.	1000
REV	*
DRWN BY	JT
CHECKED BY	JB
SCALE A0@1:100	DATE 10.02.16