


NOTES  
 CONTRACTOR TO CHECK ALL DIMENSIONS ON SITE  
 DO NOT SCALE

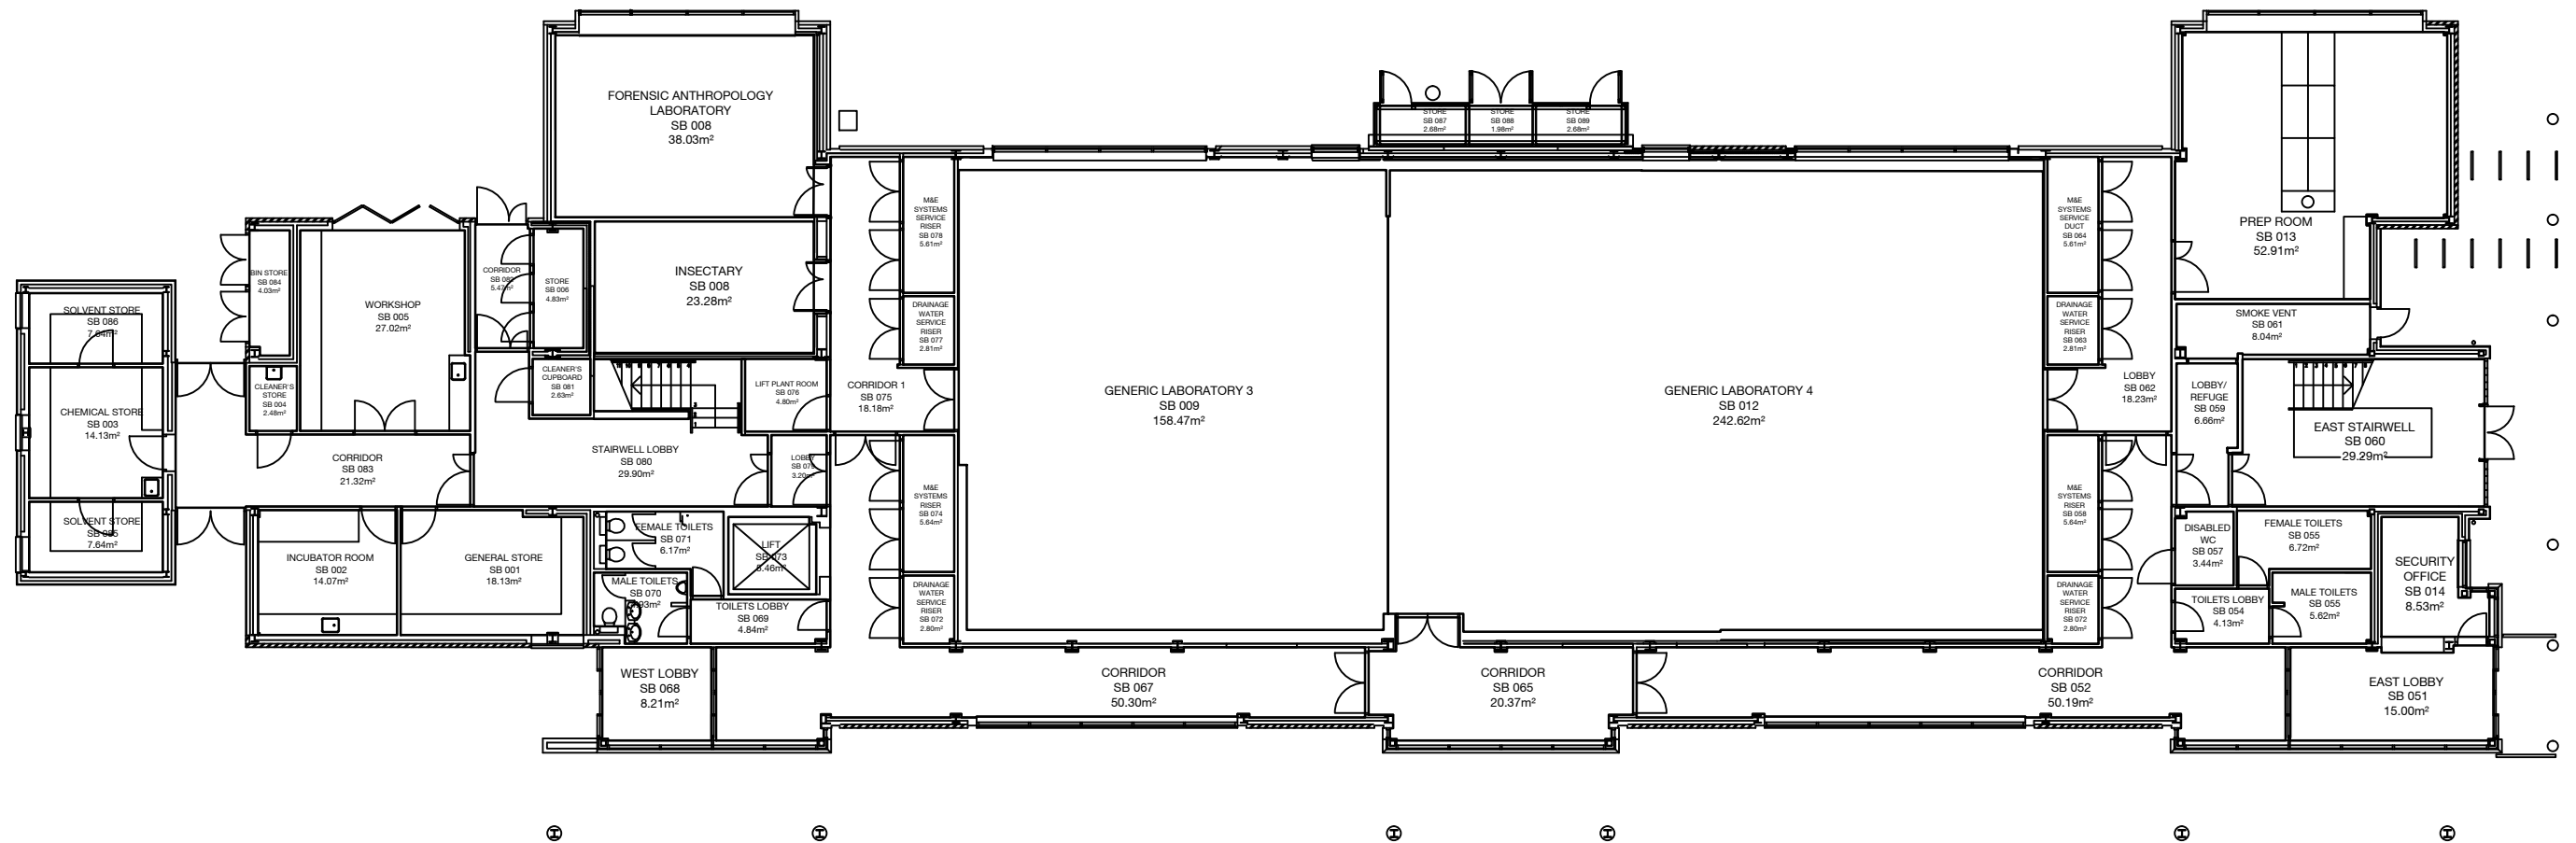

Rev	Description	Date	Drwn
-----	-------------	------	------



ESTATES AND  
 COMMERCIAL FACILITIES  
 BRAYFORD POOL  
 LINCOLN, LN6 7TS  
 TEL: 01522 886749 FAX: 01522 886247

PRN No.	BR-007
PROJECT	Science Centre Archive
PROJECT No.	N/A
DWG TITLE	Ground Floor Plan
DWG No.	1000
REV	*
DRWN BY	JT
CHECKED BY	
SCALE A1@ 1:100	DATE 01.09.15