 



NOTES
 CONTRACTOR TO CHECK ALL DIMENSIONS ON SITE
 DO NOT SCALE

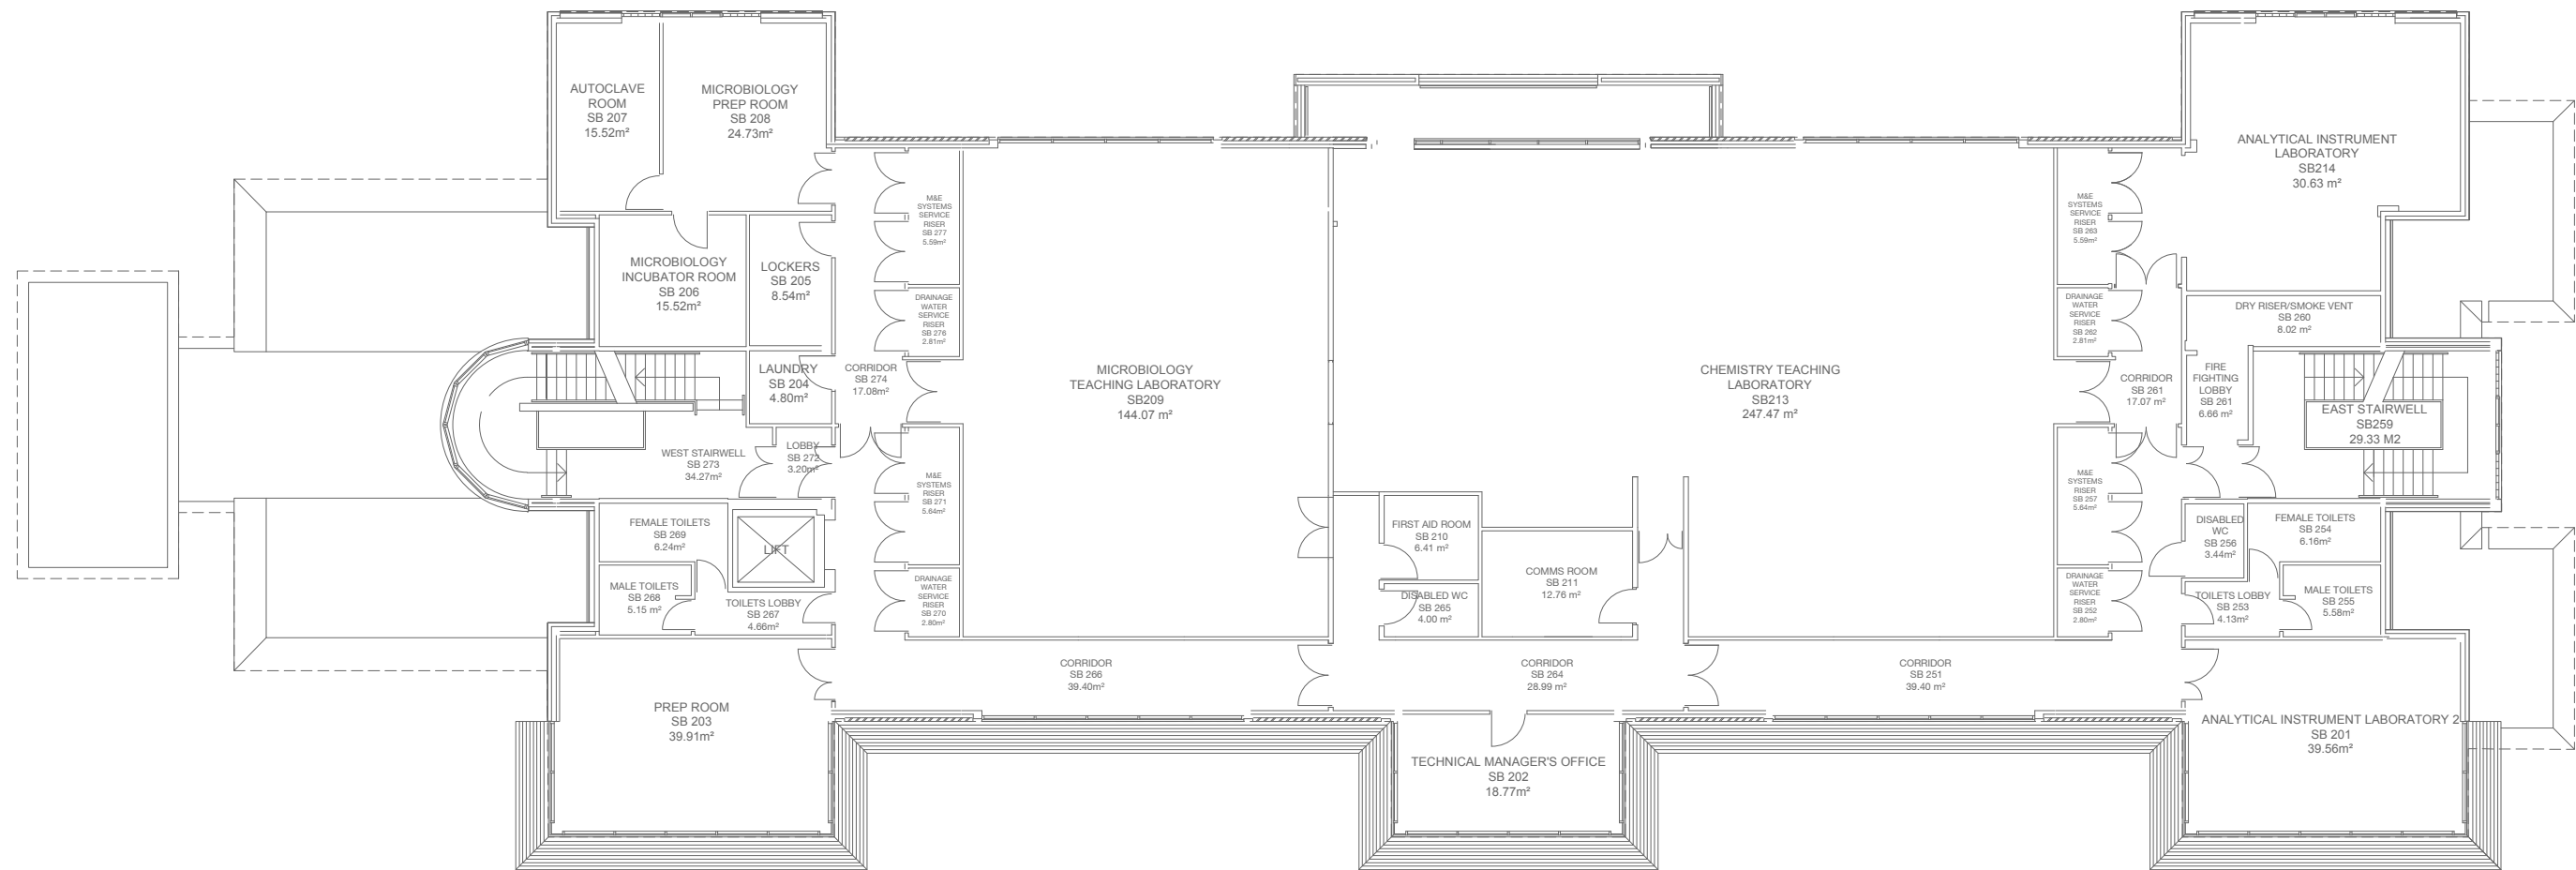

1020

Second Floor Plan
 1:200 @ A3

Rev	Description	Date	Drwn
 UNIVERSITY OF LINCOLN <small>BRAYFORD POOL LINCOLN, LN6 7TS TEL: 01522 886749 FAX: 01522 886247</small>			
PRN No. BR-007		ESTATES AND COMMERCIAL FACILITIES	
PROJECT Science Centre Archive			
PROJECT No. N/A			
DWG TITLE Second Floor Plan			
DWG No. 1020	REV *		
DRAWN BY JT	CHECKED BY		
SCALE A1@ 1:100	DATE 01.09.15		