 



NOTES
 CONTRACTOR TO CHECK ALL DIMENSIONS ON SITE
 DO NOT SCALE



Rev	Description	Date	Drwn
-----	-------------	------	------

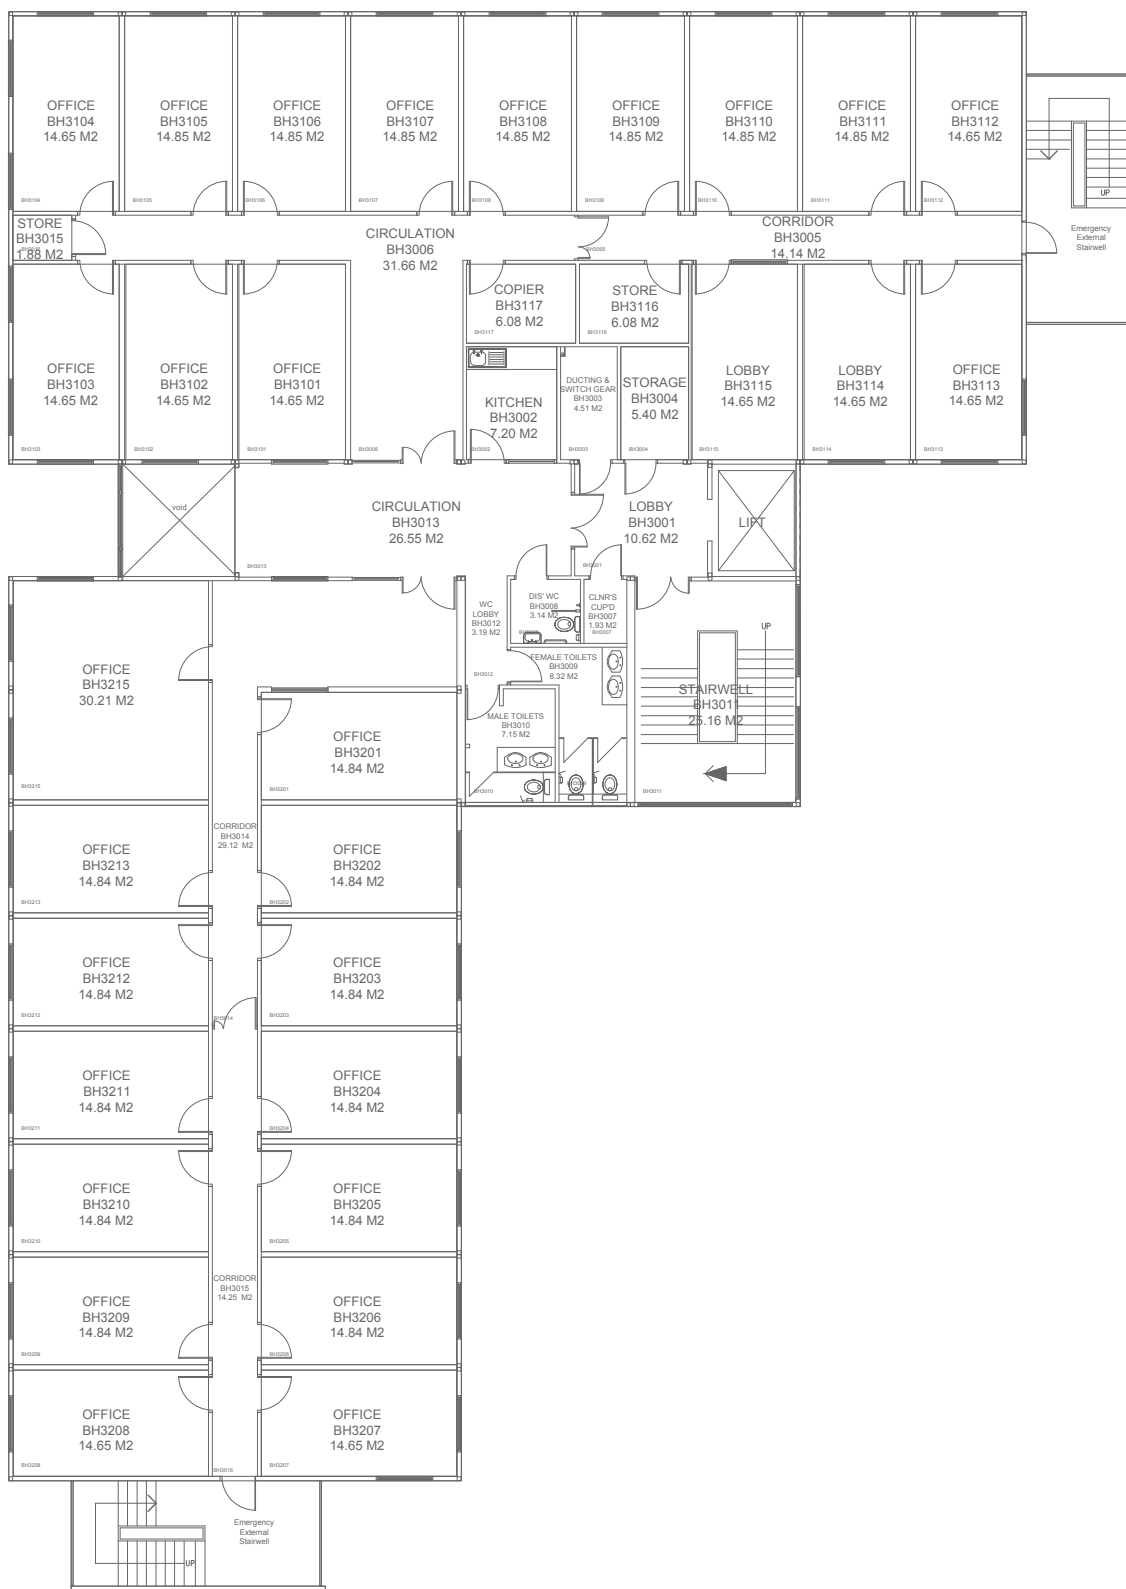

ESTATES AND
 COMMERCIAL FACILITIES
 BRAYFORD POOL
 LINCOLN, LN6 7TS
 TEL: 01522 886749 FAX: 01522 886247

PRN No.	BR-008
PROJECT	Bridge House Archive
PROJECT No.	N/A
DWG TITLE	Third Floor Plan
DWG No.	1030
REV	*
DRWN BY	JB
CHECKED BY	
SCALE	A1 @ 1:100
DATE	01.09.17

1030

Third Floor Plan

1:200 @ A3