 




NOTES
 CONTRACTOR TO CHECK ALL DIMENSIONS ON SITE
 DO NOT SCALE

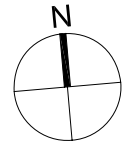

BR-015 Village Hall Room Schedule							
PRN	Room Name	Room Number	Area	GIA/GEA/NIA/NET	Floor	Department	Faculty/Service
BR-015	GEA Space	--	68.17 M2	GEA Space	03	--	--
BR-015	GEA Space	--	55.85 M2	GEA Space	03	--	--
BR-015	Lift	NUL	3.51 M2	Balance Space	03	--	--
BR-015	Plant Room	VH3052	32.98 M2	Balance Space	03	--	--
BR-015	Stairs	VH3051	16.93 M2	Balance Space	03	--	--

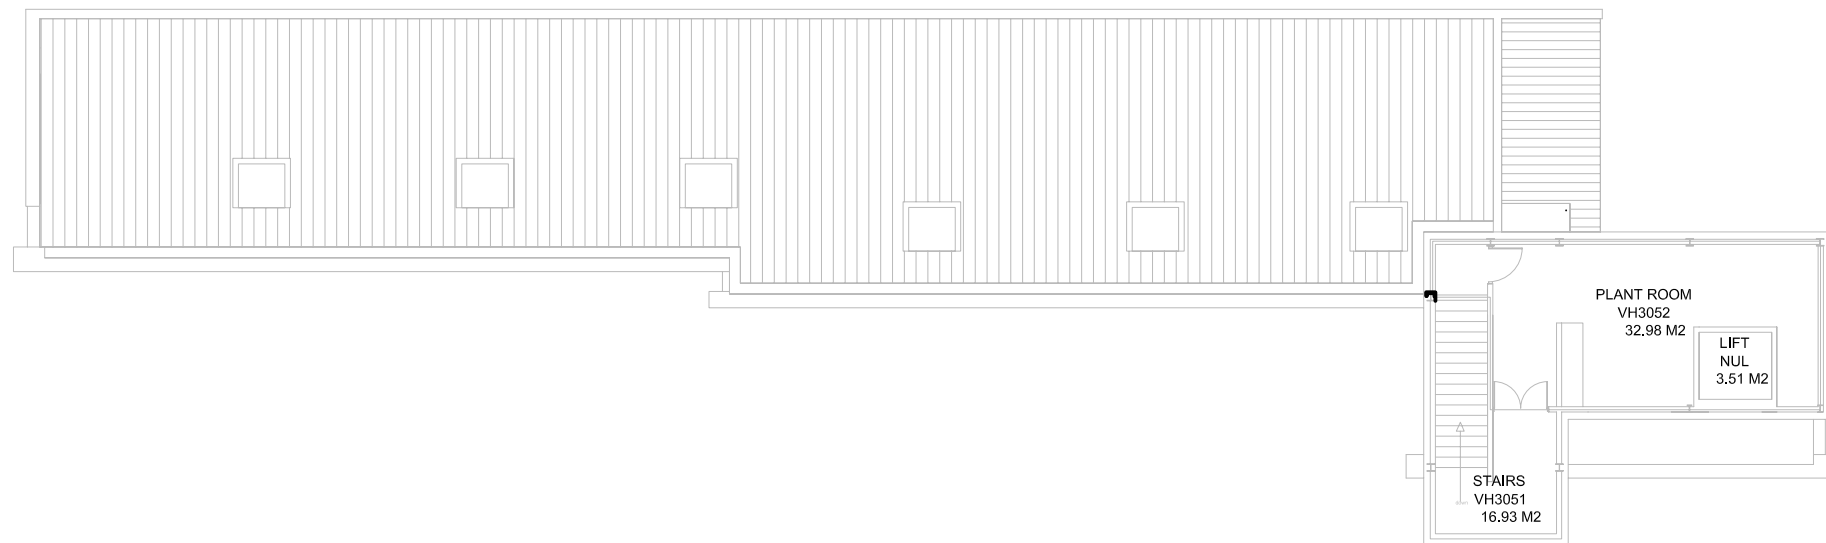

Rev	Description	Date	Drwn



ESTATES AND
 COMMERCIAL FACILITIES
 BRAYFORD POOL
 LINCOLN LN6 7TS
 TEL: 01522 886749 FAX: 01522 886247

PRN No. **BR-015**
 PROJECT **Village Hall Archive**
 PROJECT No. **N/A**
 DWG TITLE **Plantroom Floor Plan**

DWG No. **1030** REV *****

DRWN BY **JB** CHECKED BY
 SCALE A1@ 1:100 DATE **23.09.13**

1030 Plantroom Floor Plan
 1:200 @ A3