 
 



NOTES
 CONTRACTOR TO CHECK ALL DIMENSIONS ON SITE
 DO NOT SCALE



1000
 Ground Floor Plan
 1:100 @ A3

Rev	Description	Date	Drwn
A	CSB0006 Added	11.05.16	RN

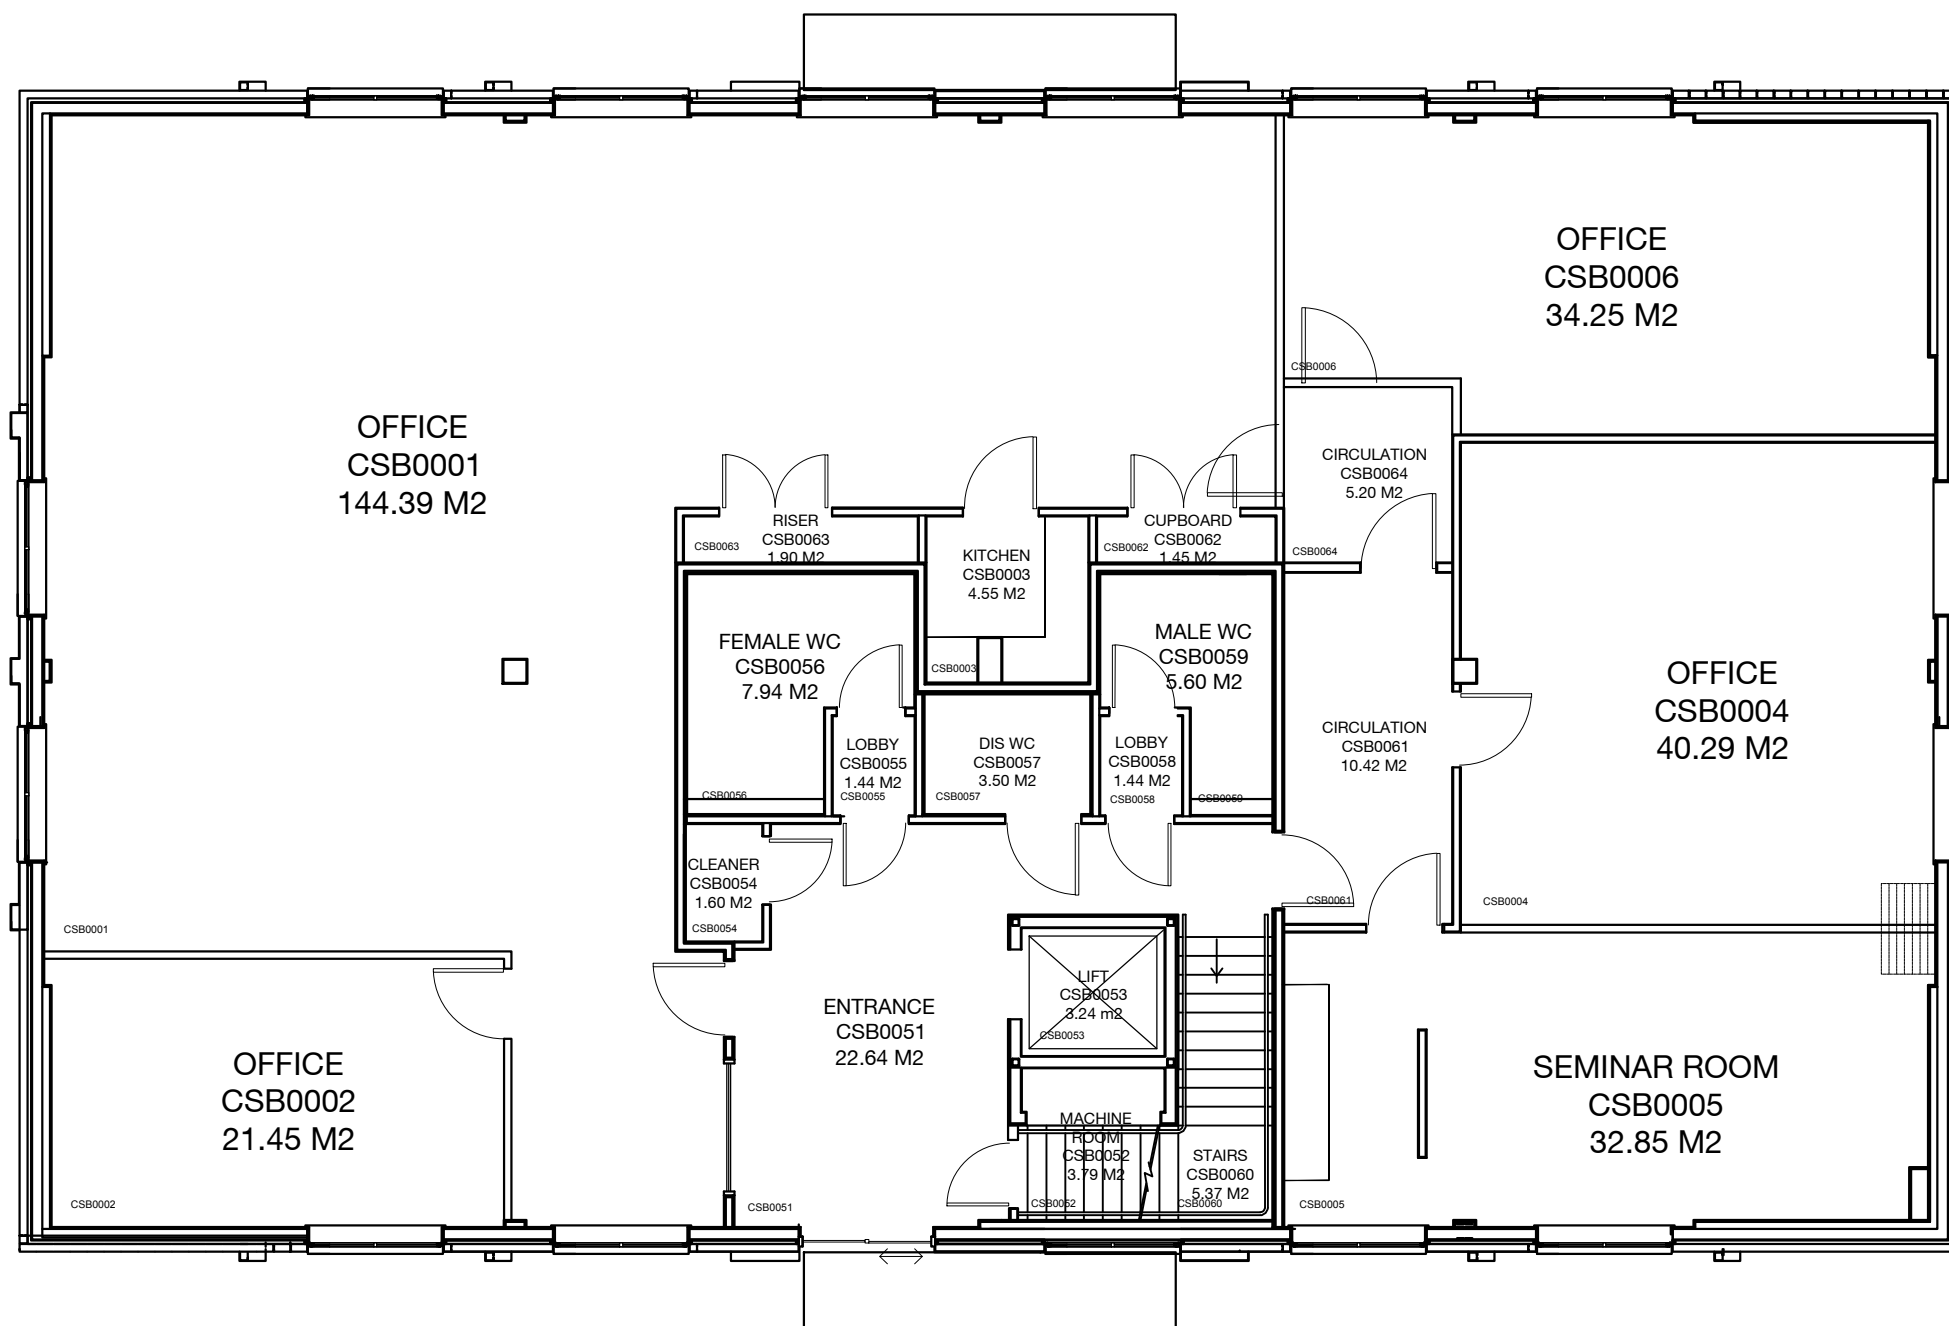

ESTATES AND
 COMMERCIAL FACILITIES
 BRAYFORD POOL
 LINCOLN, LN6 7TS
 TEL: 01522 886749 FAX: 01522 886247

PRN No.	BR-087
PROJECT	Charlotte Scott Building Archive
PROJECT No.	N/A
DWG TITLE	Ground Floor Plan
DWG No.	1000
REV	A
DRWN BY	JB
CHECKED BY	
SCALE A1 @ 1:50	DATE 04.04.14