

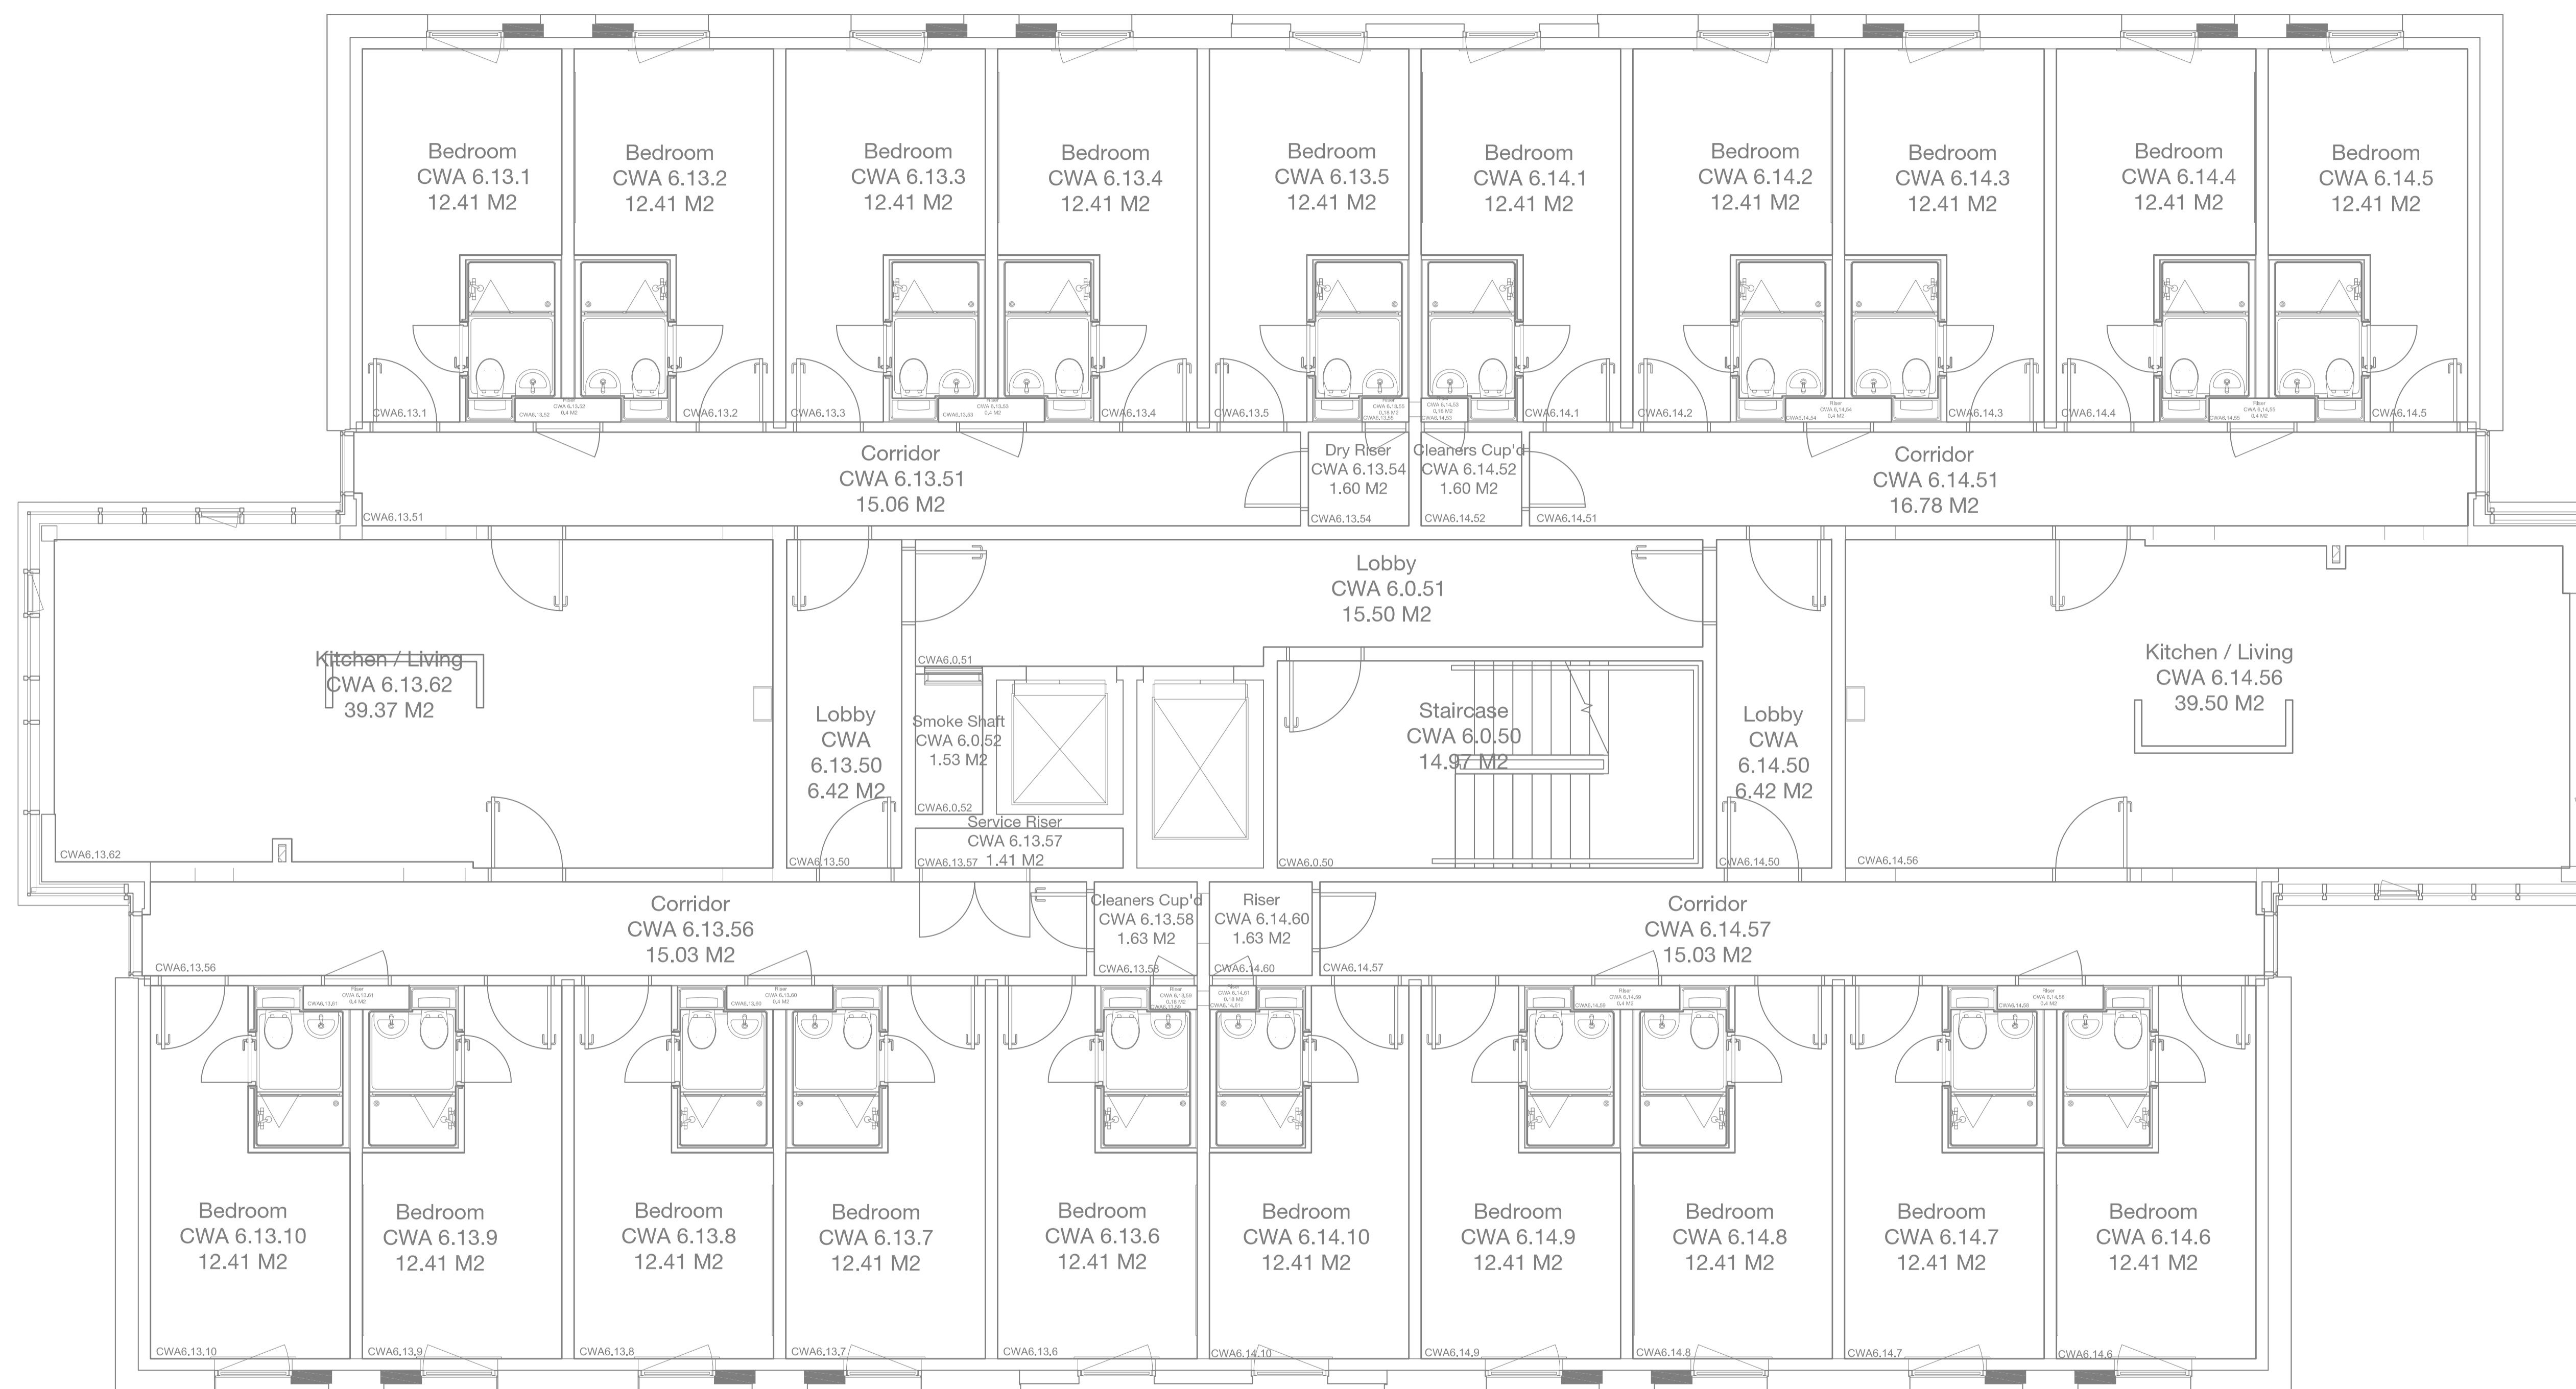


NOTES  
 CONTRACTOR TO CHECK ALL DIMENSIONS ON SITE  
 DO NOT SCALE

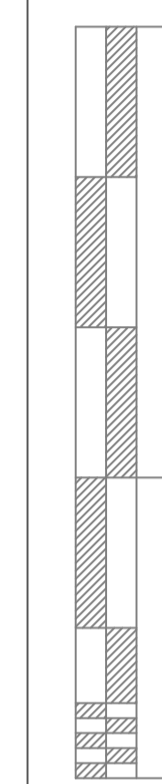

1060 Sixth Floor Plan  
 1:50 @ A1

Rev	Description	Date	Drwn

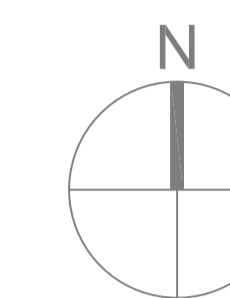

ESTATES AND  
 CAMPUS SERVICES  
 CHARLOTTE SCOTT BUILDING  
 BRAYFORD POOL  
 LINCOLN LN6 7FL  
 TEL: 01522 886749 FAX: 01522 886247

PRN No.	BR-129
PROJECT	Cygnets Wharf A
PROJECT No.	-
DWG TITLE	Sixth Floor Layout
DWG No.	1060
REV	(-)
DRWN BY	RN
CHECKED BY	-
SCALE	A1 @ 1:50
DATE	14.09.17