

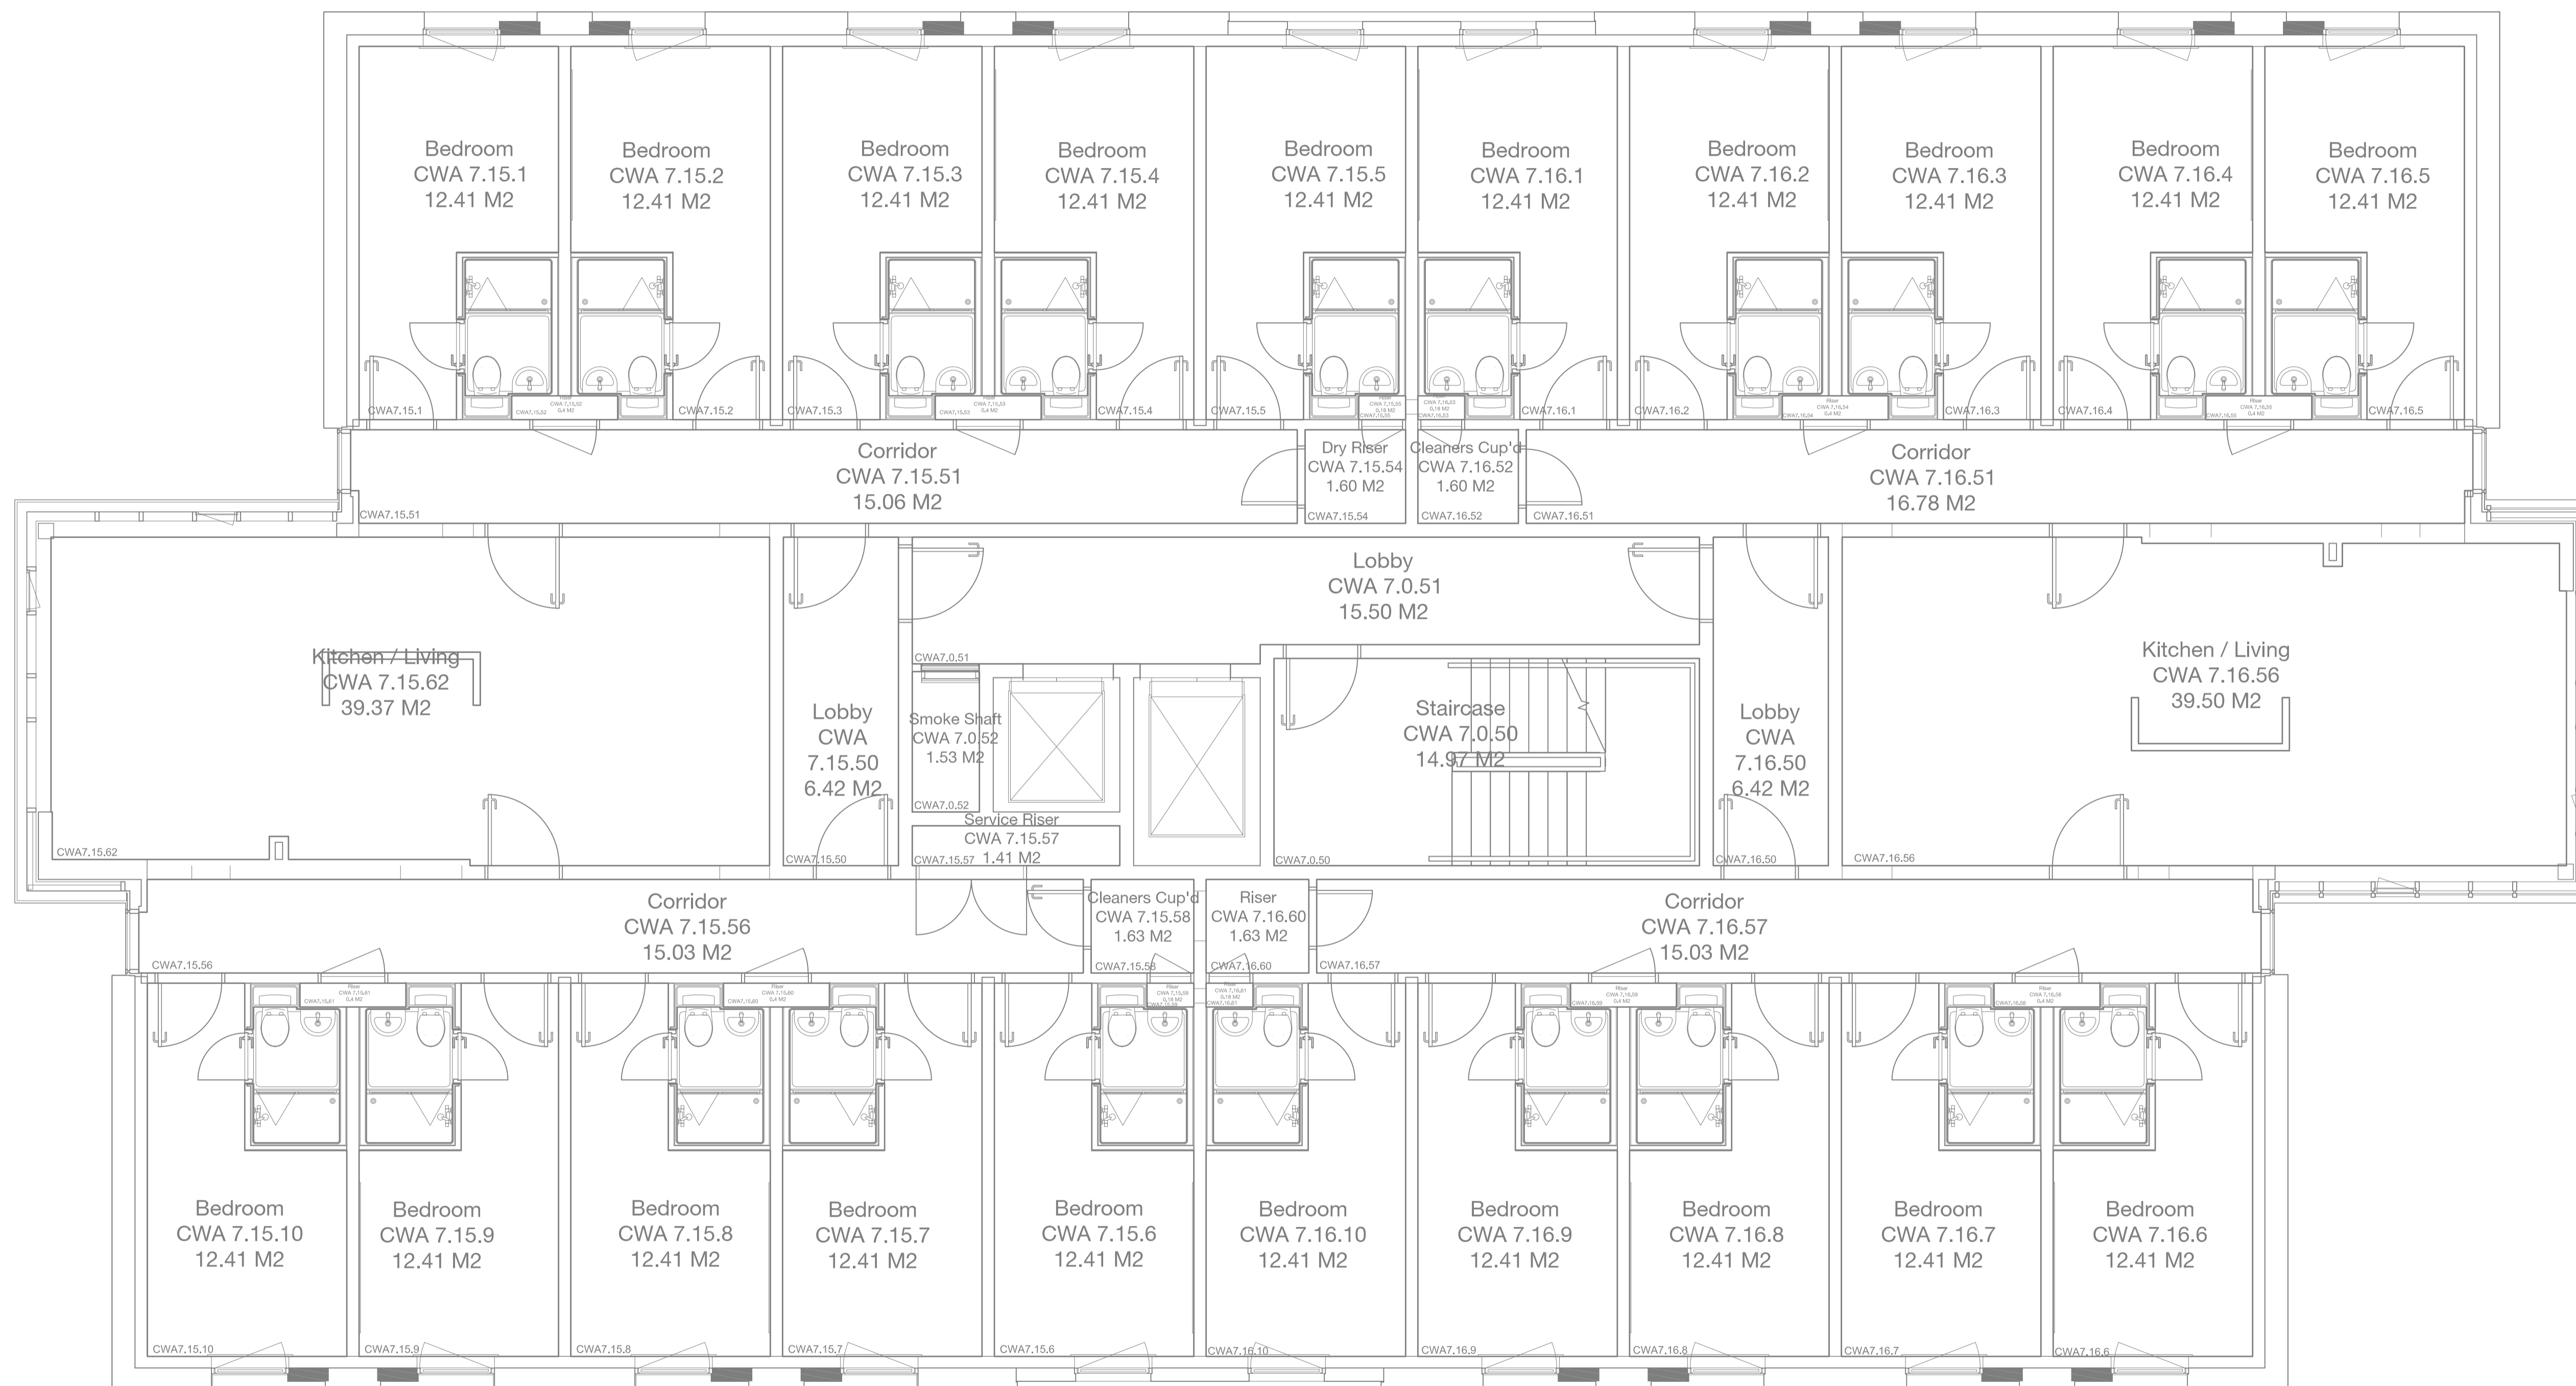


NOTES
 CONTRACTOR TO CHECK ALL DIMENSIONS ON SITE
 DO NOT SCALE

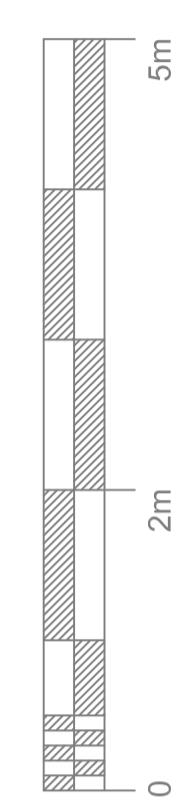

Rev	Description	Date	Drwn

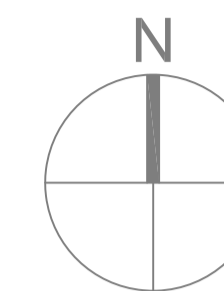

ESTATES AND
 CAMPUS SERVICES
 CHARLOTTE SCOTT BUILDING
 BRAYFORD POOL
 LINCOLN LN6 7FL
 TEL: 01522 886749 FAX: 01522 886247

PRN No.	BR-129
PROJECT	Cygnets Wharf A
PROJECT No.	-
DWG TITLE	Seventh Floor Layout
DWG No.	1070
REV	(-)
DRWN BY	RN
CHECKED BY	-
SCALE	A1 @ 1:50
DATE	14.09.17

1070 Seventh Floor Plan
 1:50 @ A1