
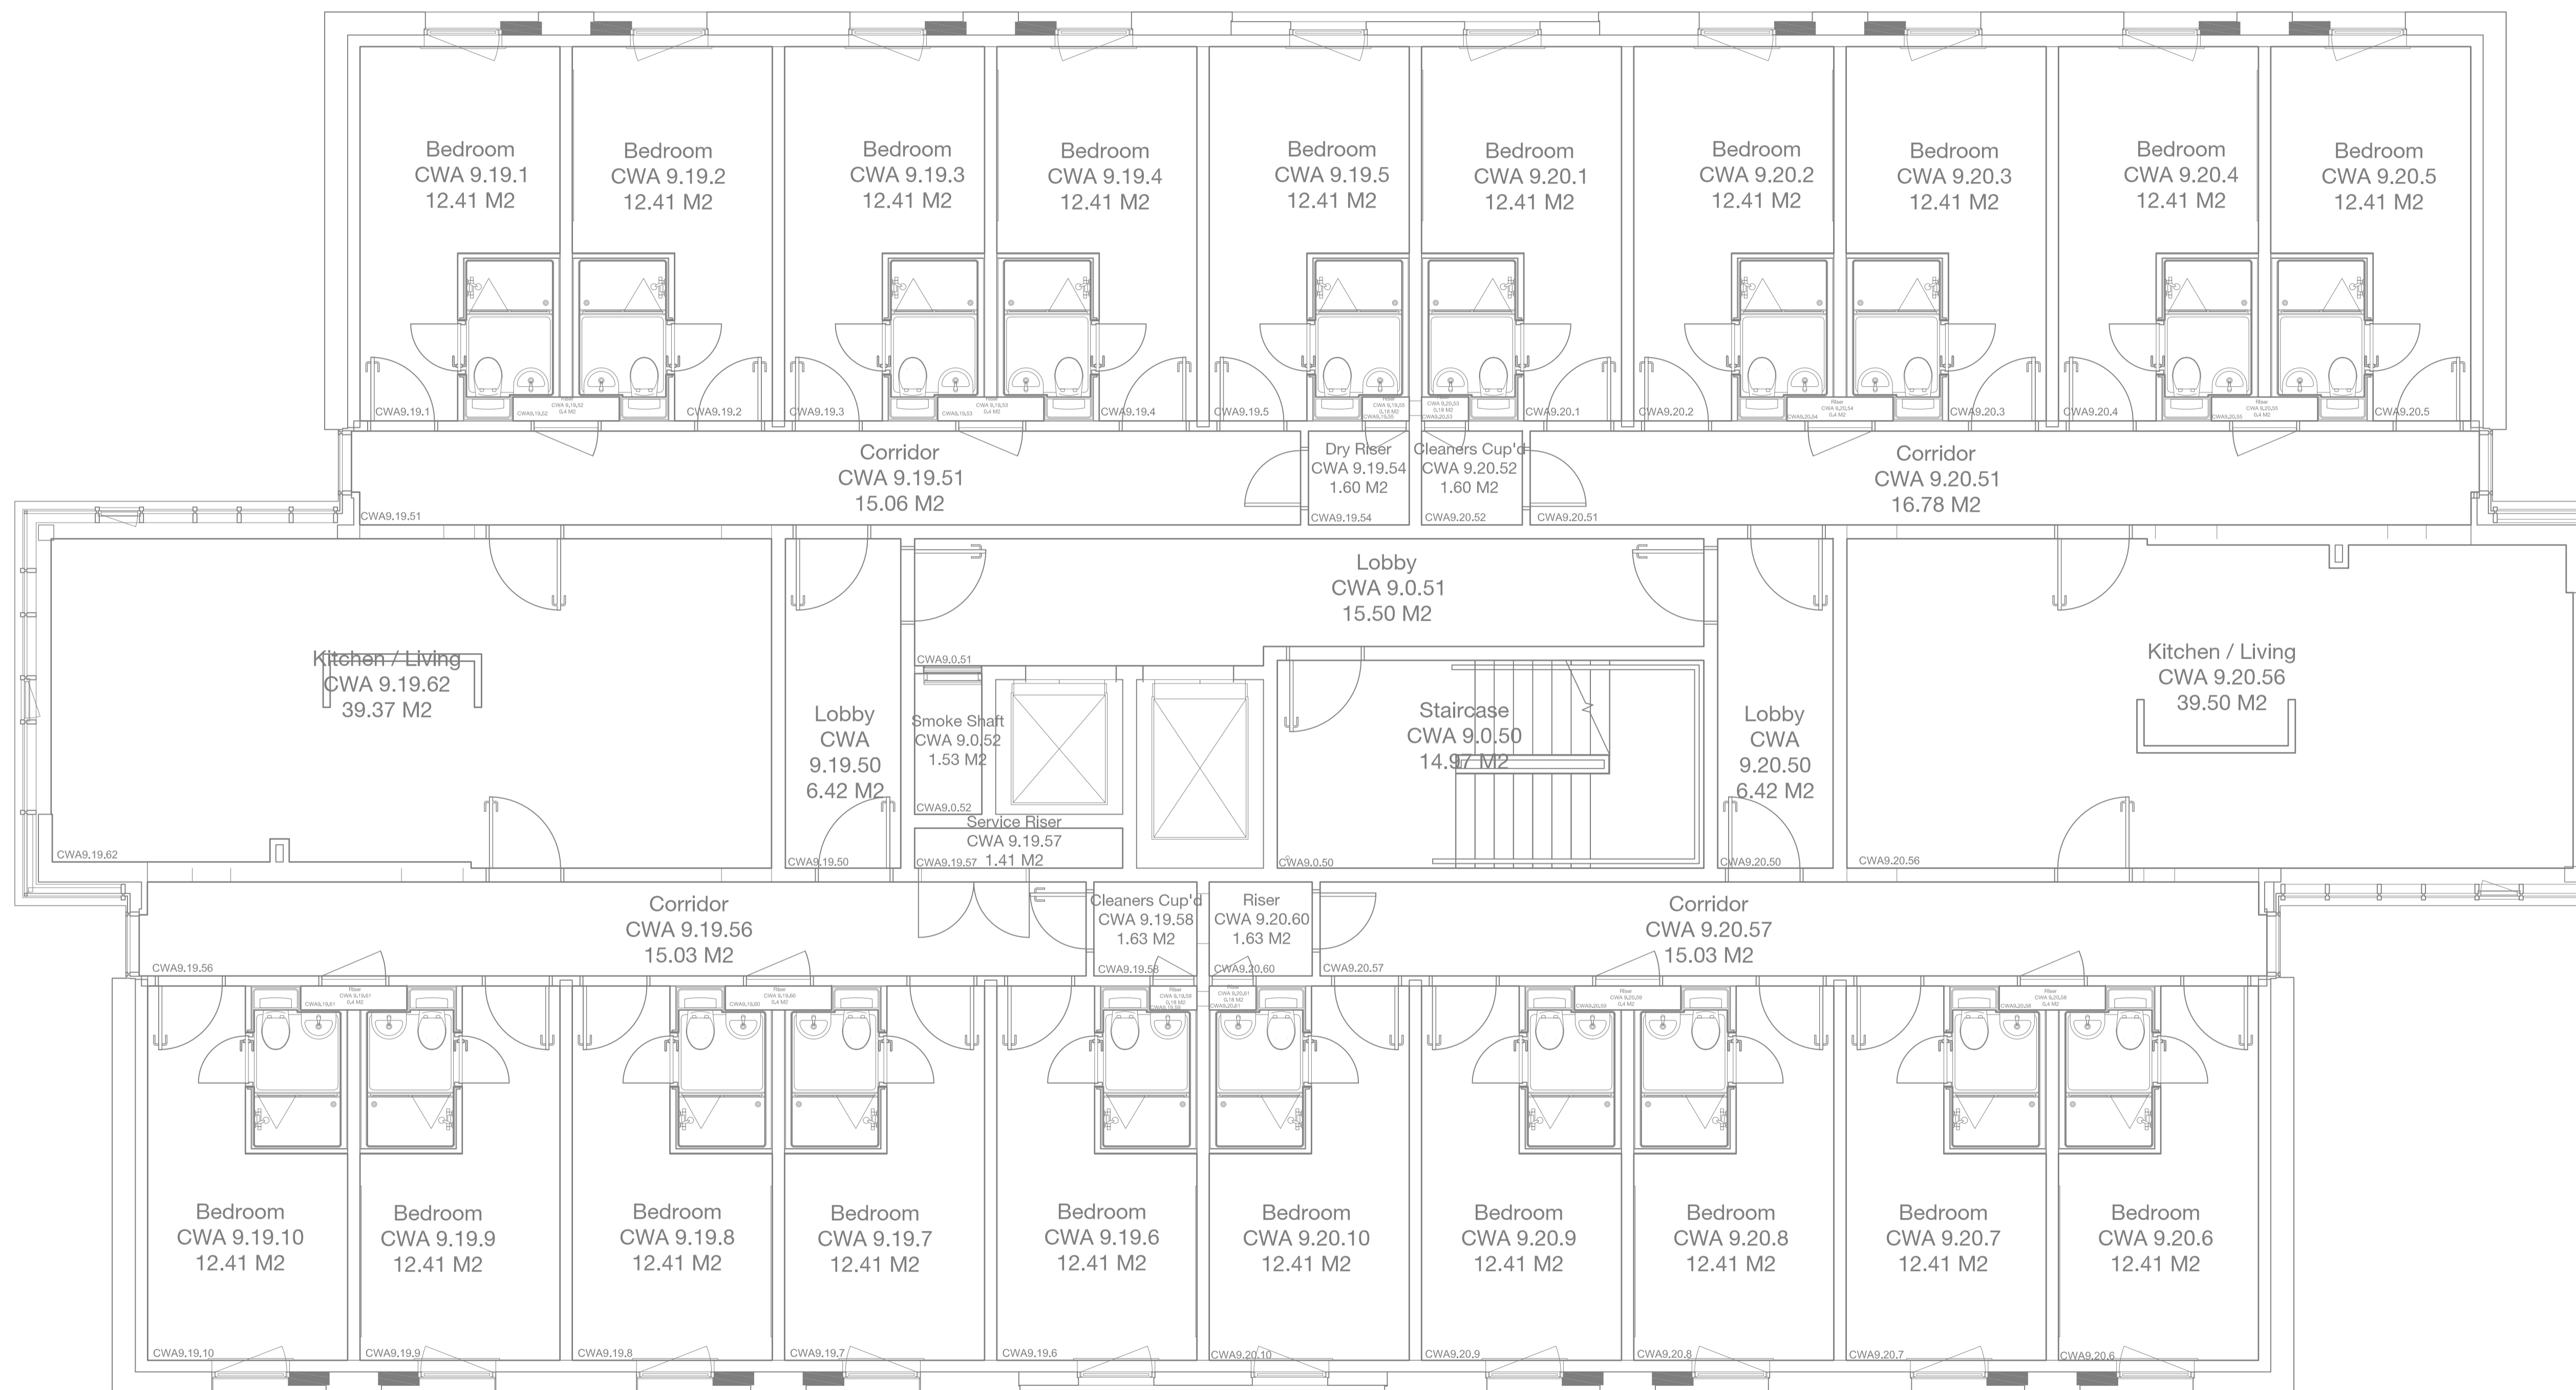
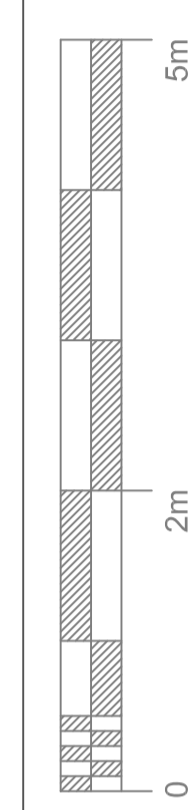


NOTES
 CONTRACTOR TO CHECK ALL DIMENSIONS ON SITE
 DO NOT SCALE

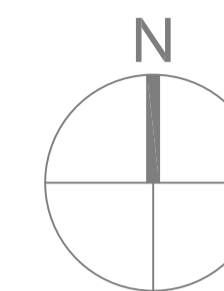

1090 Ninth Floor Plan
 1:50 @ A1

Rev	Description	Date	Drwn


ESTATES AND CAMPUS SERVICES
 CHARLOTTE SCOTT BUILDING
 BRAYFORD POOL
 LINCOLN, LN6 7FL
 TEL: 01522 886749 FAX: 01522 886247

PRN No.	BR-129
PROJECT	Cygnets Wharf A
PROJECT No.	
DWG TITLE	Ninth Floor Layout
DWG No.	1090
REV	(-)
DRWN BY	RN
CHECKED BY	
SCALE	A1 @ 1:50
DATE	14.09.17