
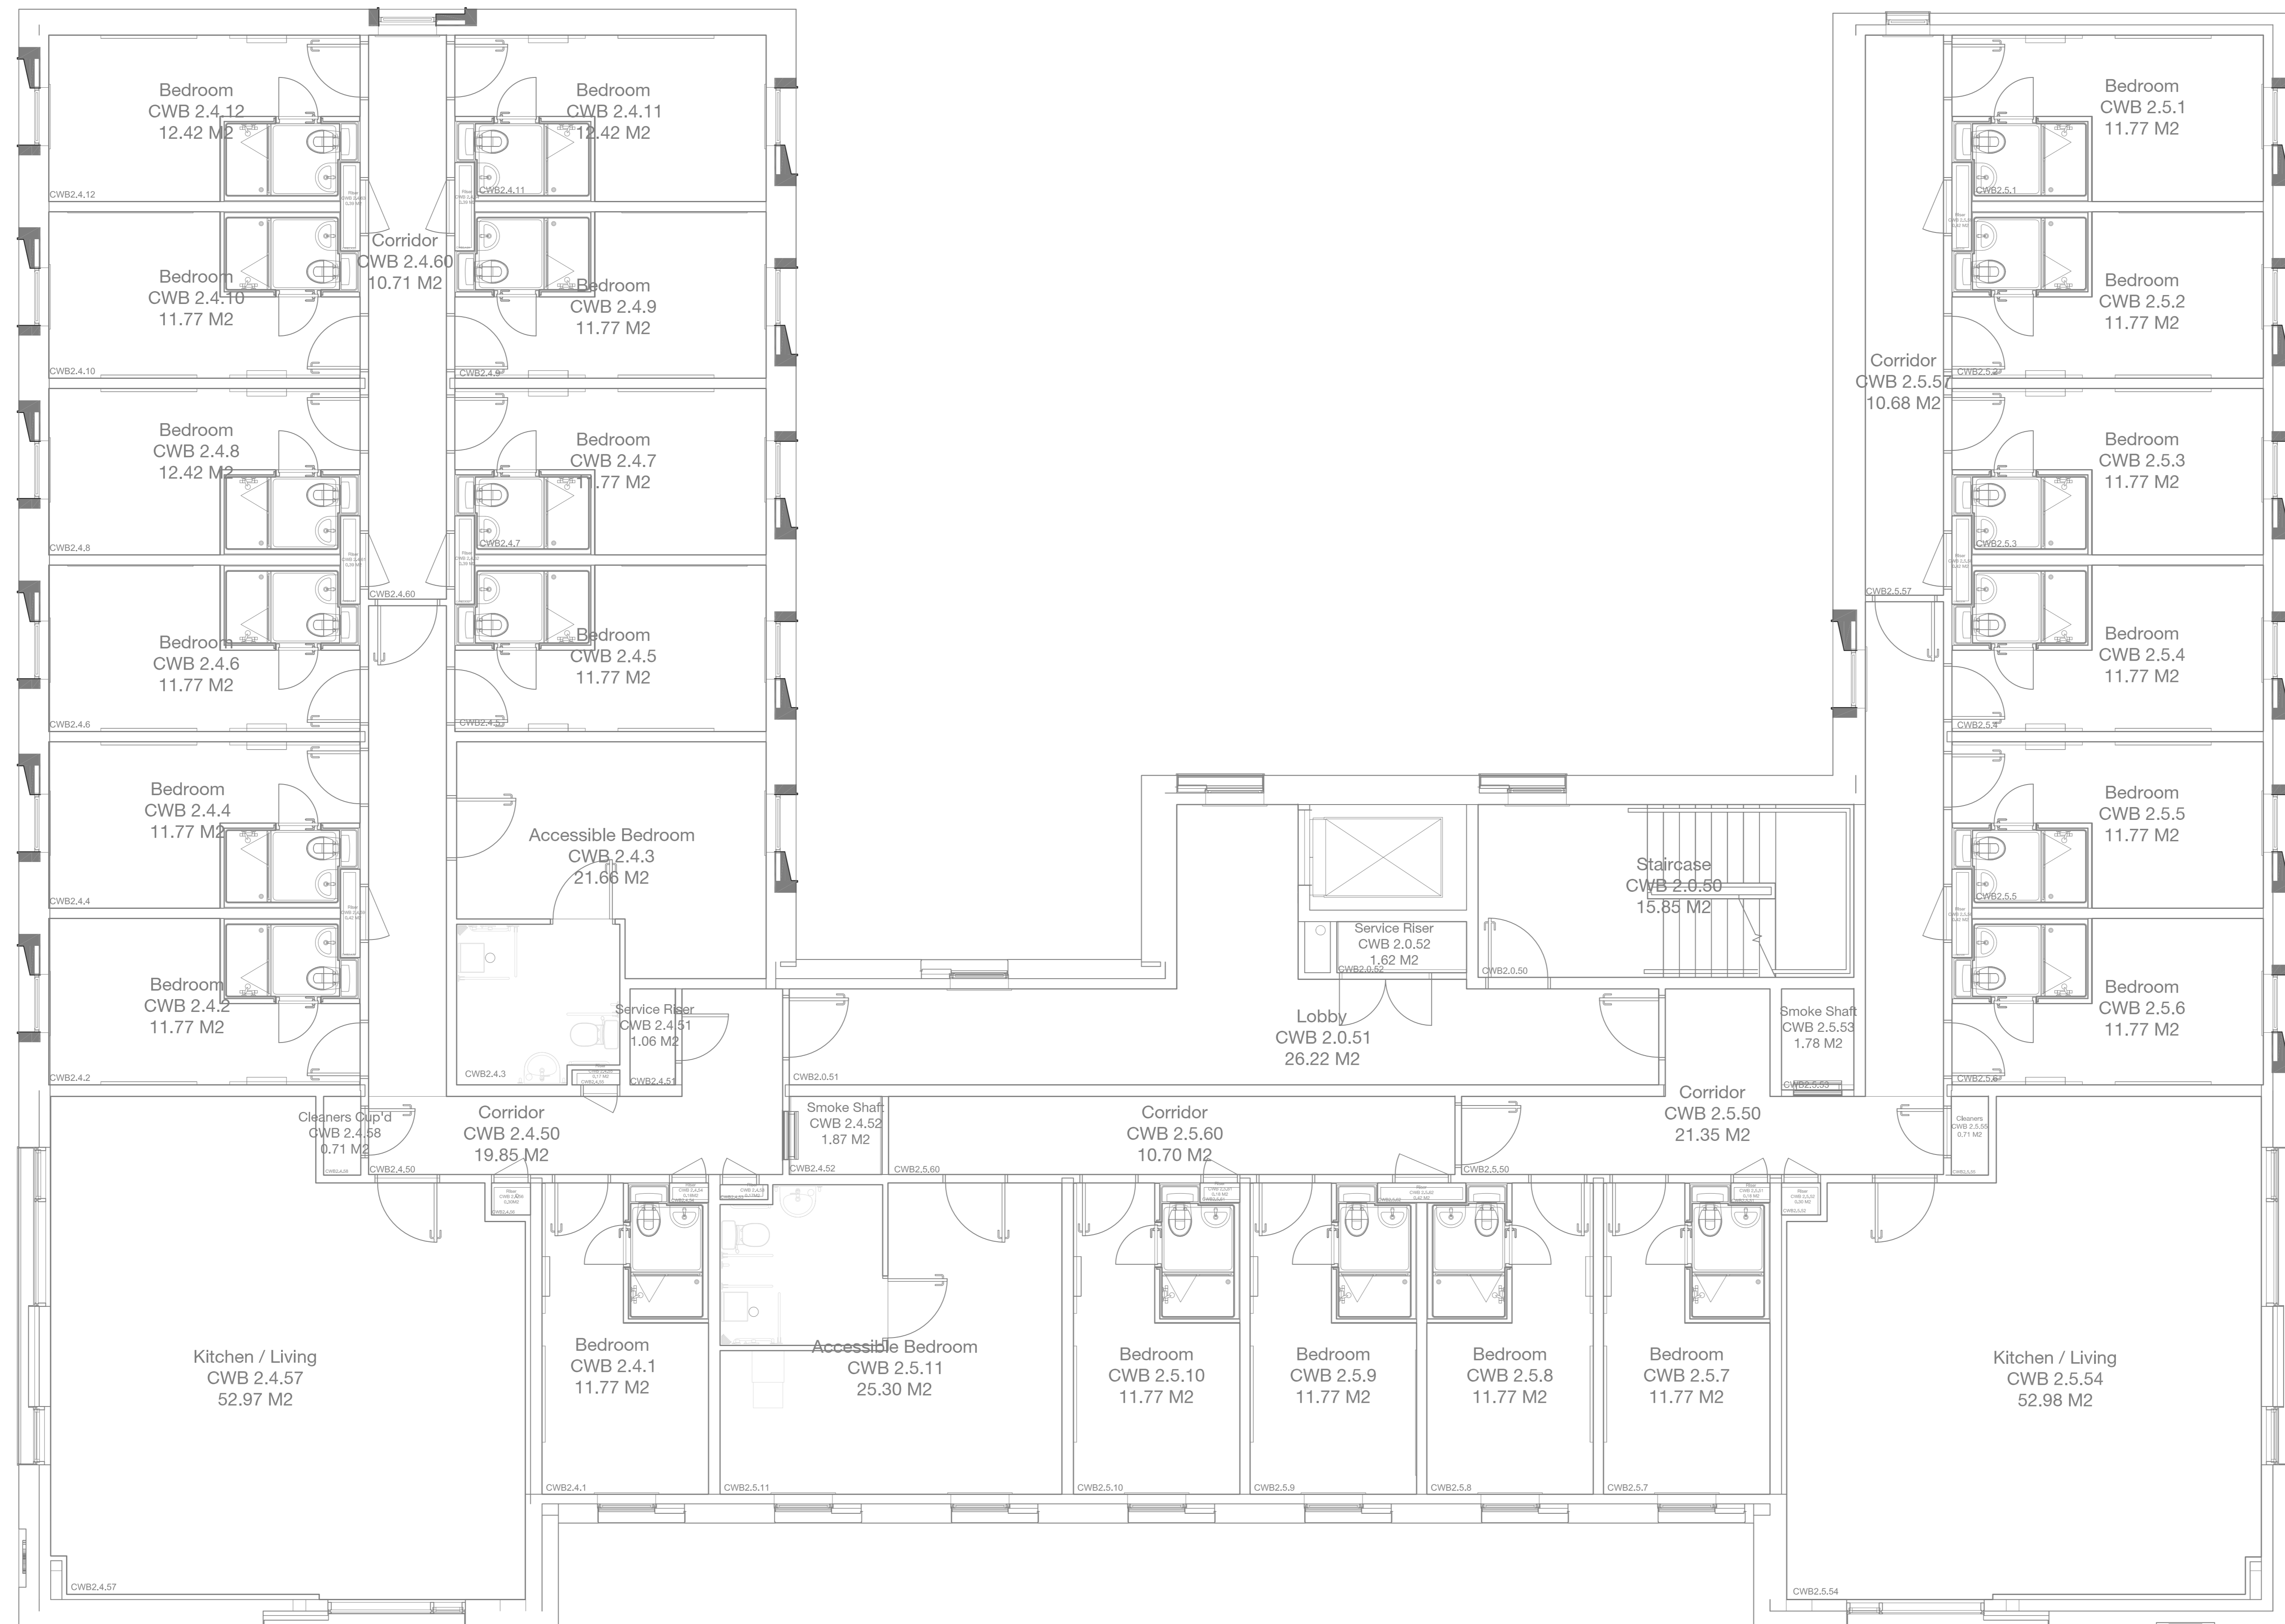
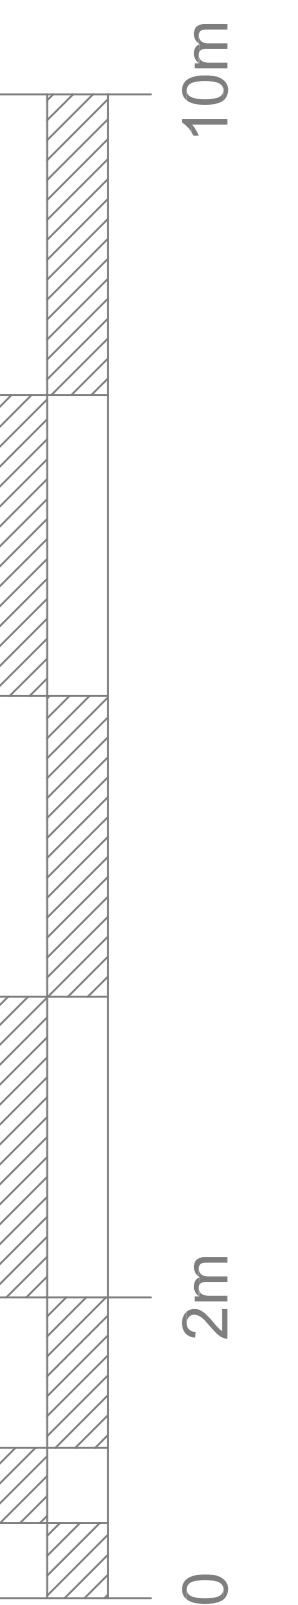


NOTES
 CONTRACTOR TO CHECK ALL DIMENSIONS ON SITE
 DO NOT SCALE

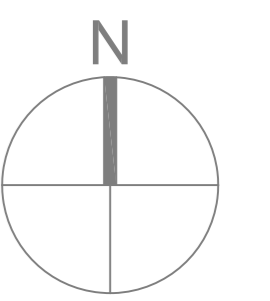

1020

Second Floor Plan
 1:50 @ A0

Rev	Description	Date	Drawn



**ESTATES AND
 CAMPUS SERVICES**
 CHARLOTTE SCOTT BUILDING
 BRAYFORD POOL
 LINCOLN, LN6 7TL
 TEL: 01522 886748 FAX: 01522 886347

PRN No.	BR-130
PROJECT	Cygnets Wharf B
PROJECT No.	-
DWG TITLE	Second Floor Layout
DWG No.	REV
	1020 (-)
DRWN BY	RN
CHECKED BY	
SCALE	A0@ 1:50
DATE	14.09.17