
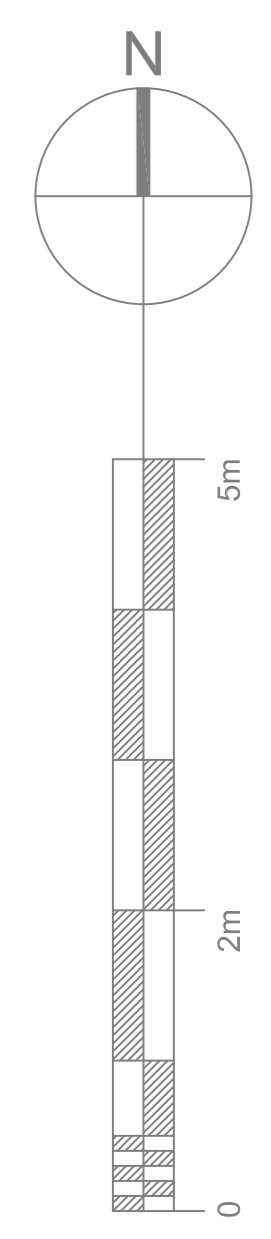



NOTES
 CONTRACTOR TO CHECK ALL DIMENSIONS ON SITE
 DO NOT SCALE

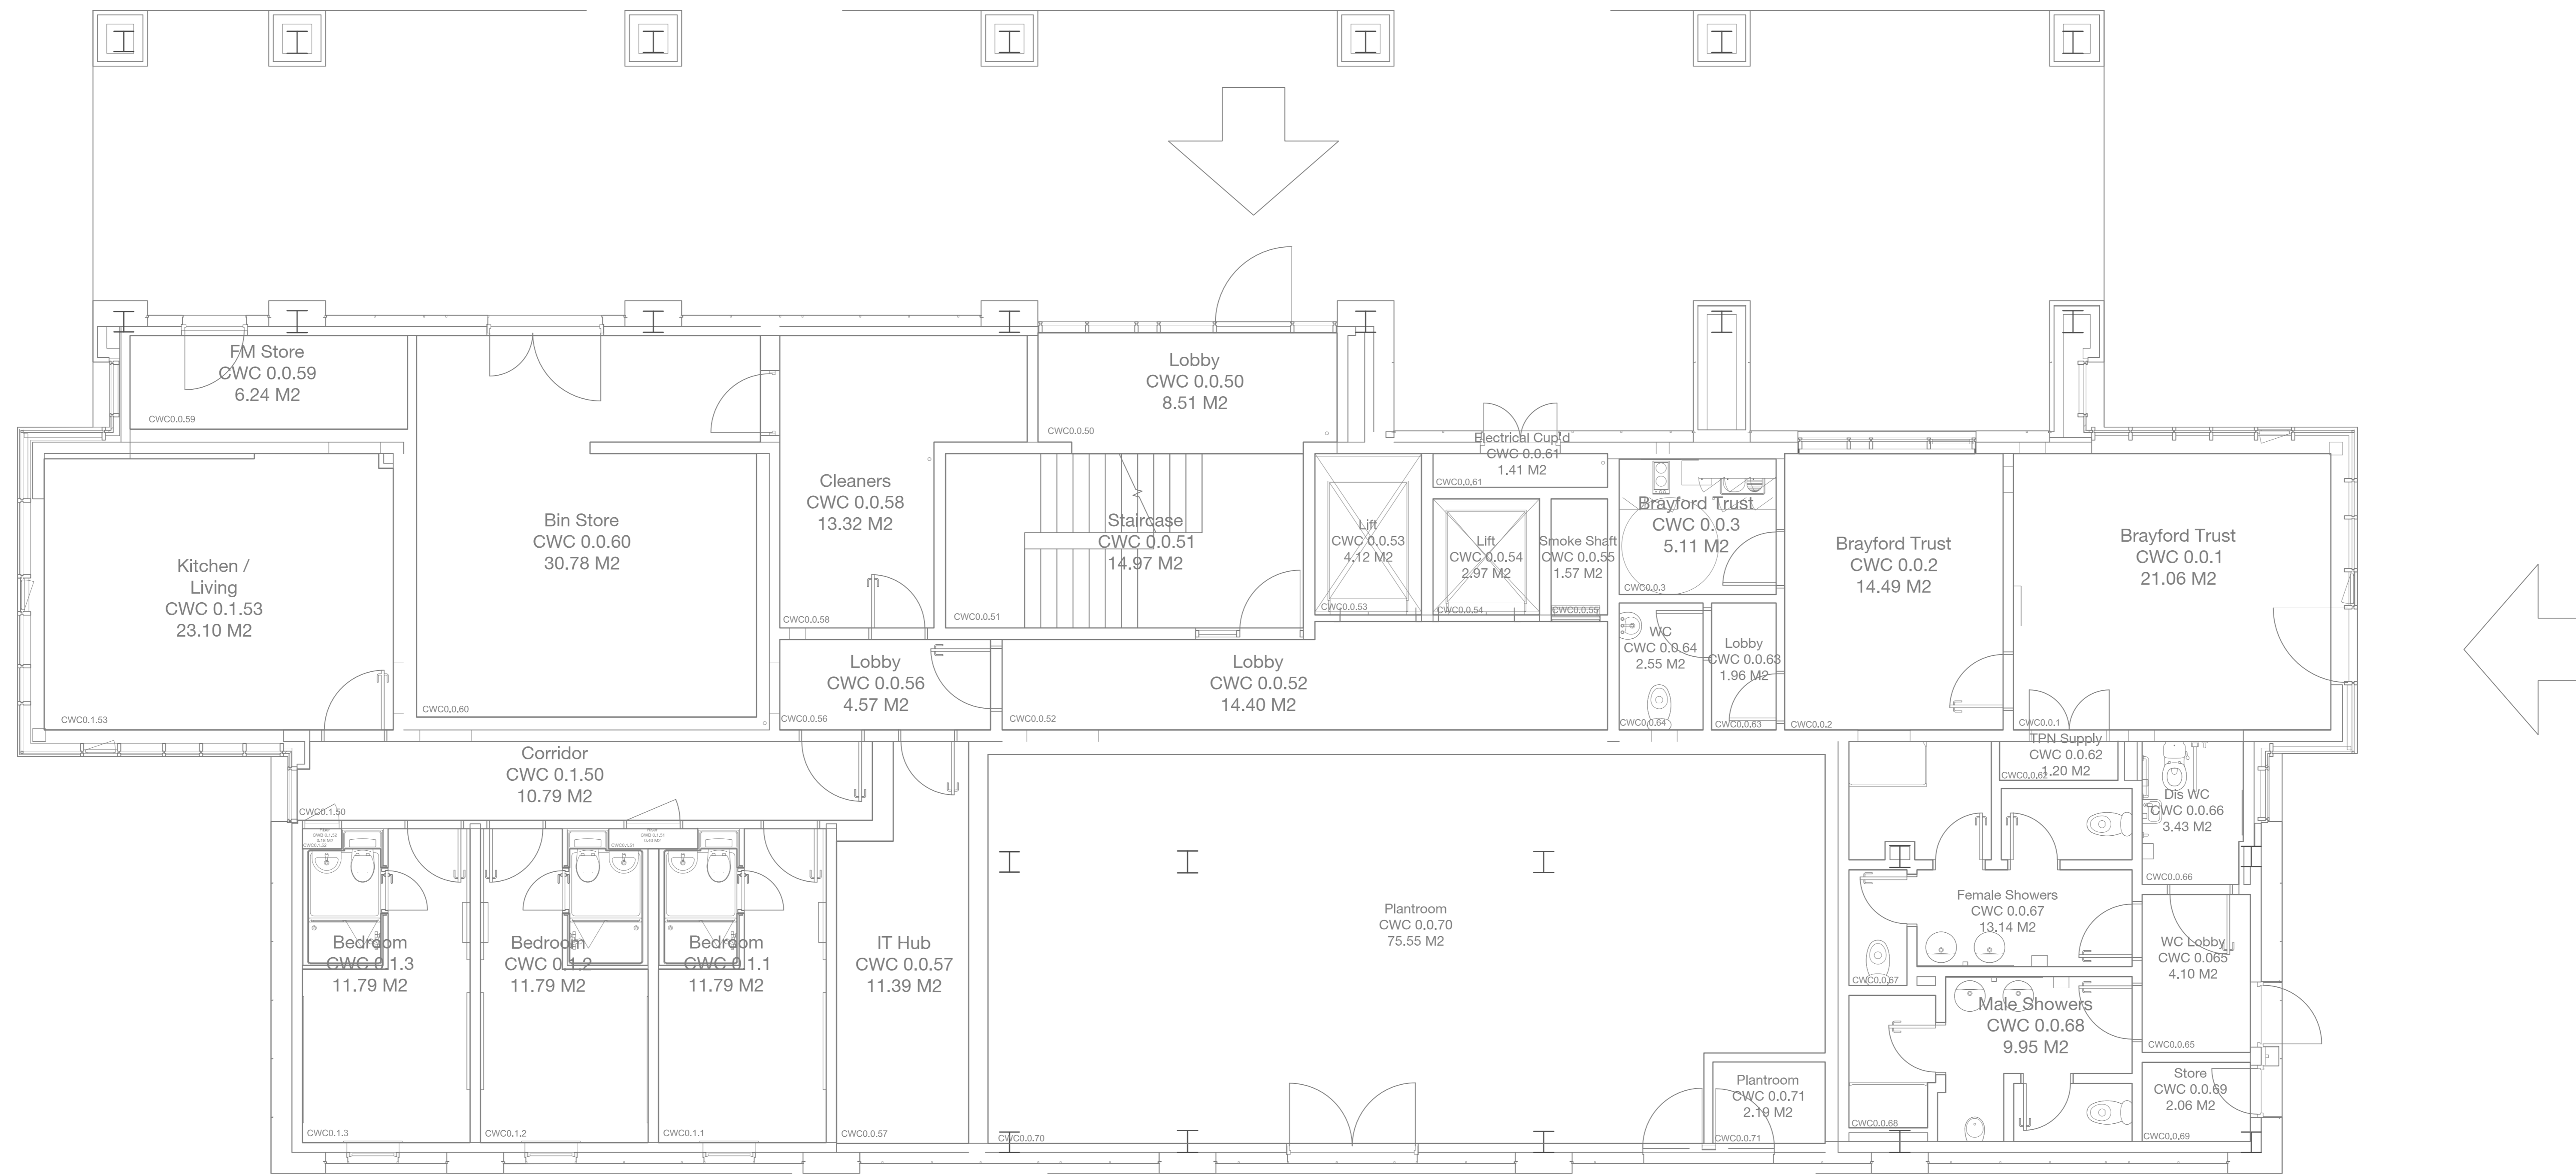

1000 Ground Floor Plan
 1:50 @ A0

Rev	Description	Date	Drawn


ESTATES AND CAMPUS SERVICES
 CHELLOTTE SCOTT BUILDING
 BRAYFORD POOL
 LINCOLN, LN6 7TL
 TEL: 01522 886748 FAX: 01522 886247

PRN No.	BR-131
PROJECT	Cygnets Wharf C
PROJECT No.	-
DWG TITLE	Ground Floor Layout
DWG No.	REV
	1000 (-)
DRWN BY	RN
CHECKED BY	-
SCALE	A0@ 1:50
DATE	14.09.17