

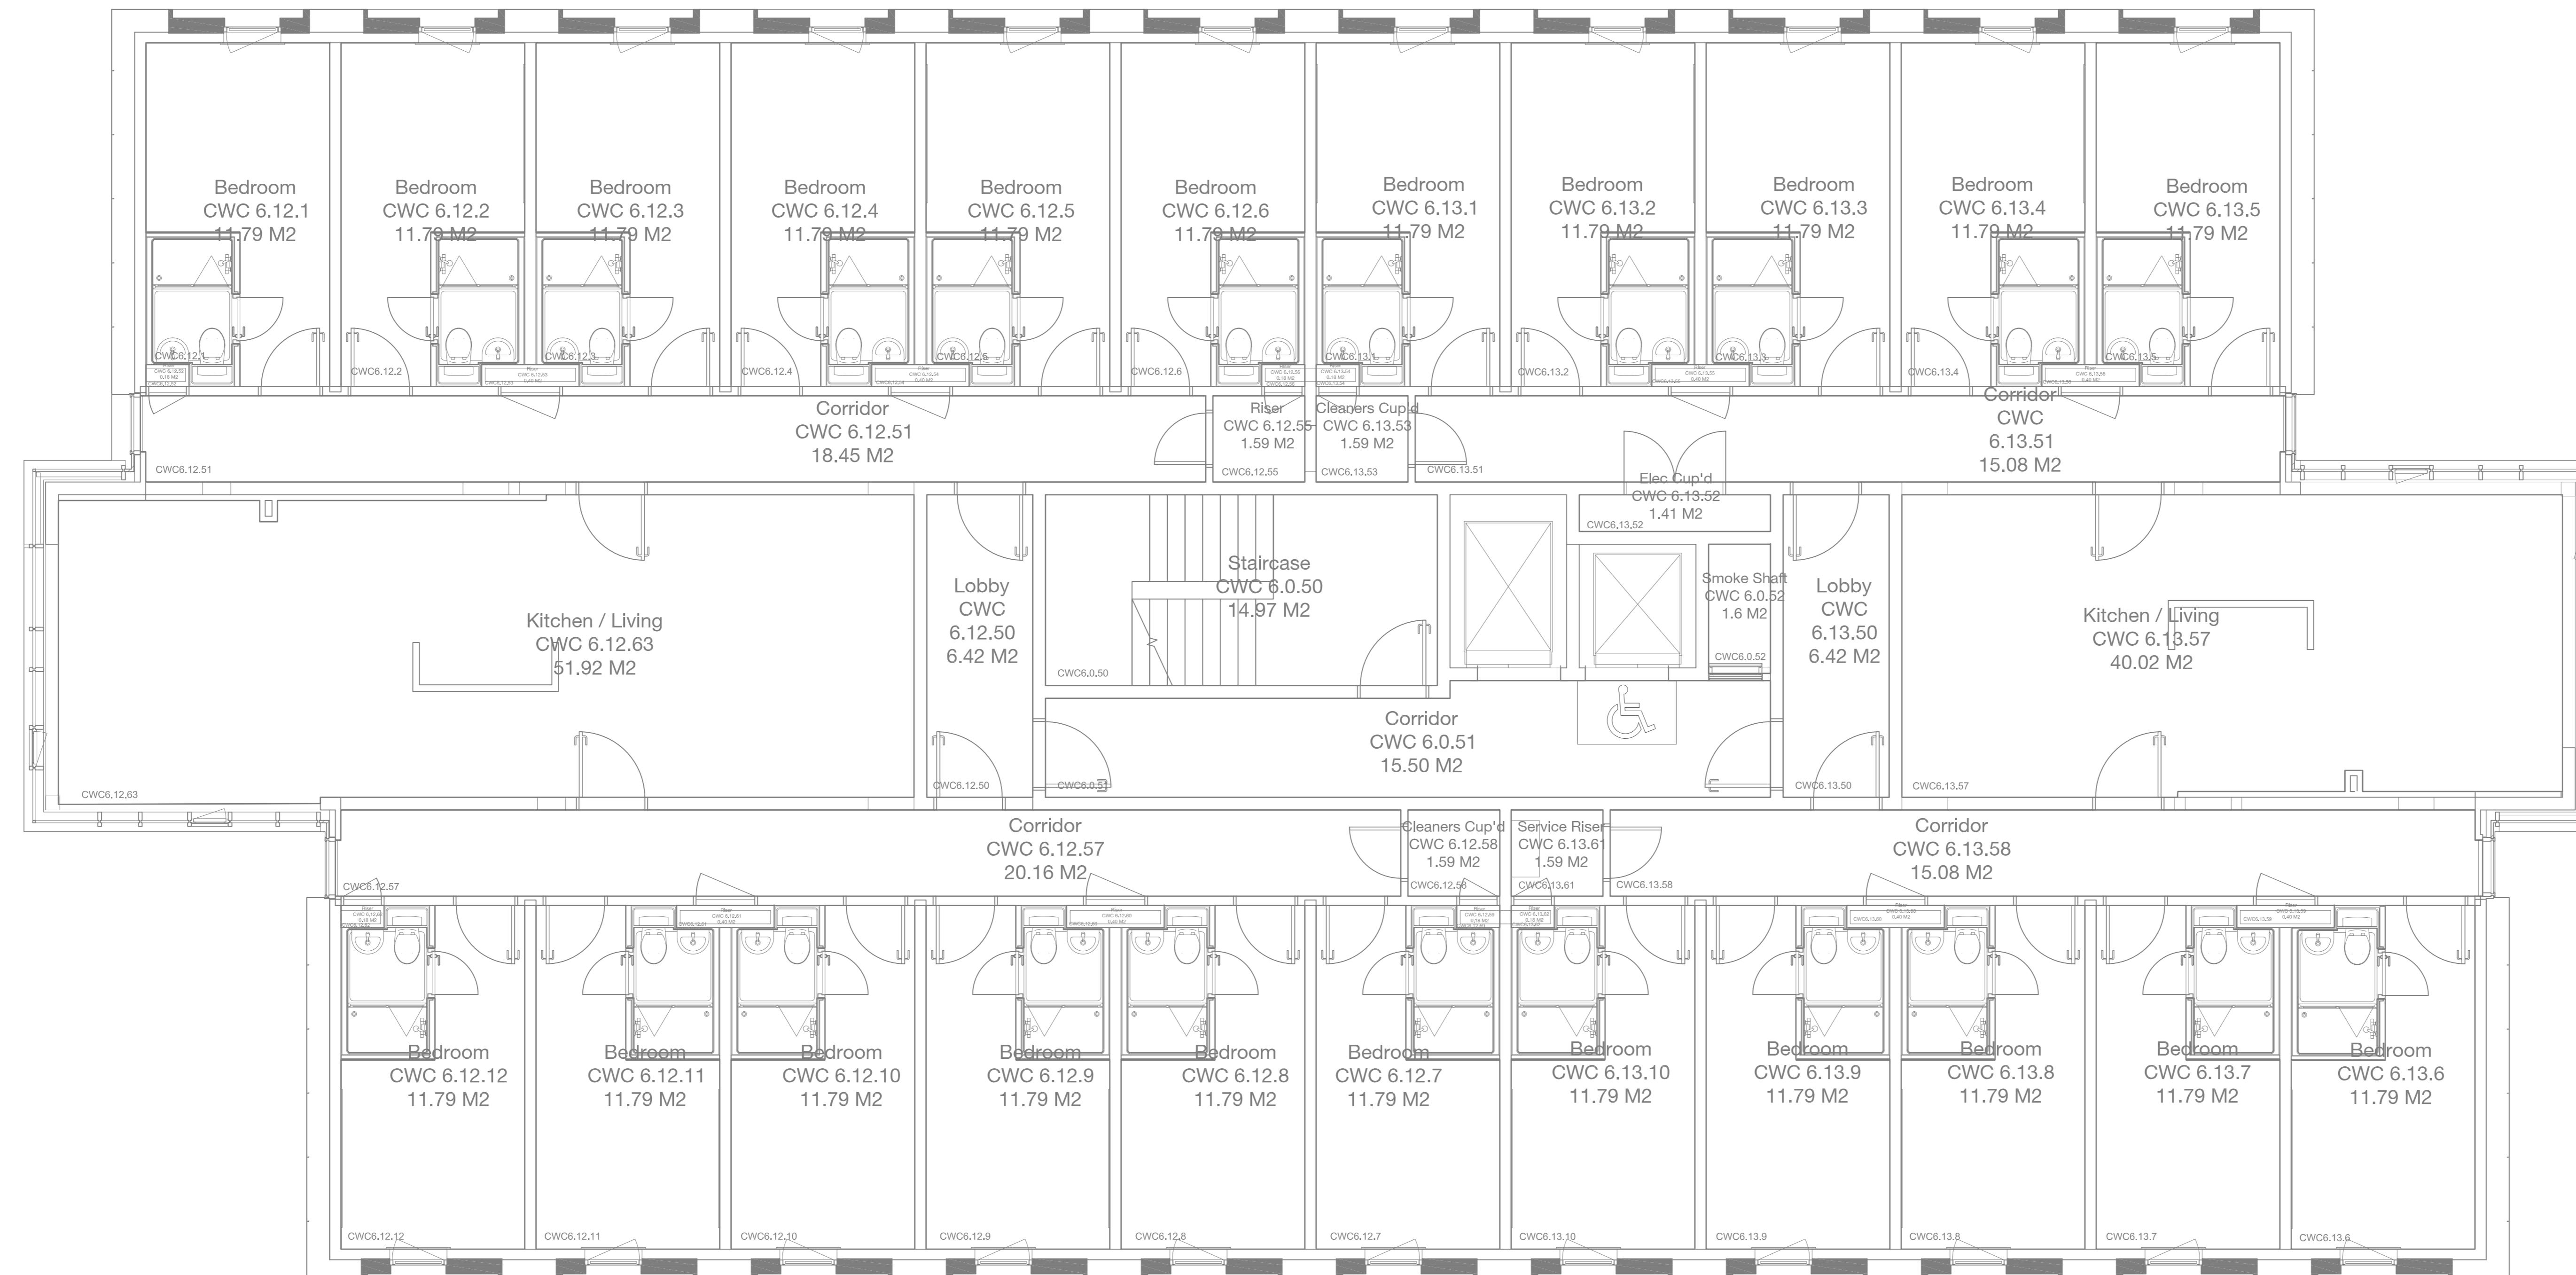


NOTES
 CONTRACTOR TO CHECK ALL DIMENSIONS ON SITE
 DO NOT SCALE

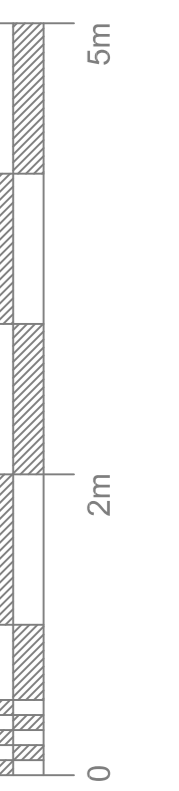

1060 Sixth Floor Plan
 1:50 @ A0

Rev	Description	Date	Drawn

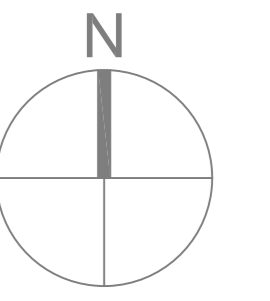

**ESTATES AND
 CAMPUS SERVICES**
 CHAPELLATE SCOTT BUILDING
 BRUNNERS FOSCOE
 LINCOLN, LN6 7TL
 TEL: 01522 886748 FAX: 01522 886347

PRN No.	BR-130
PROJECT	Cygnnet Wharf C
PROJECT No.	
DWG TITLE	Sixth Floor Layout
DWG No.	1060
REV	(-)
DRWN BY	RN
CHECKED BY	-
SCALE	A0@ 1:50
DATE	14.09.17