
 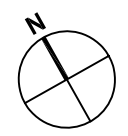

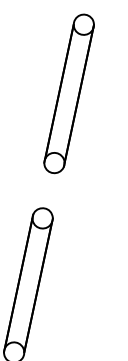


NOTES
CONTRACTOR TO CHECK ALL DIMENSIONS ON SITE
DO NOT SCALE

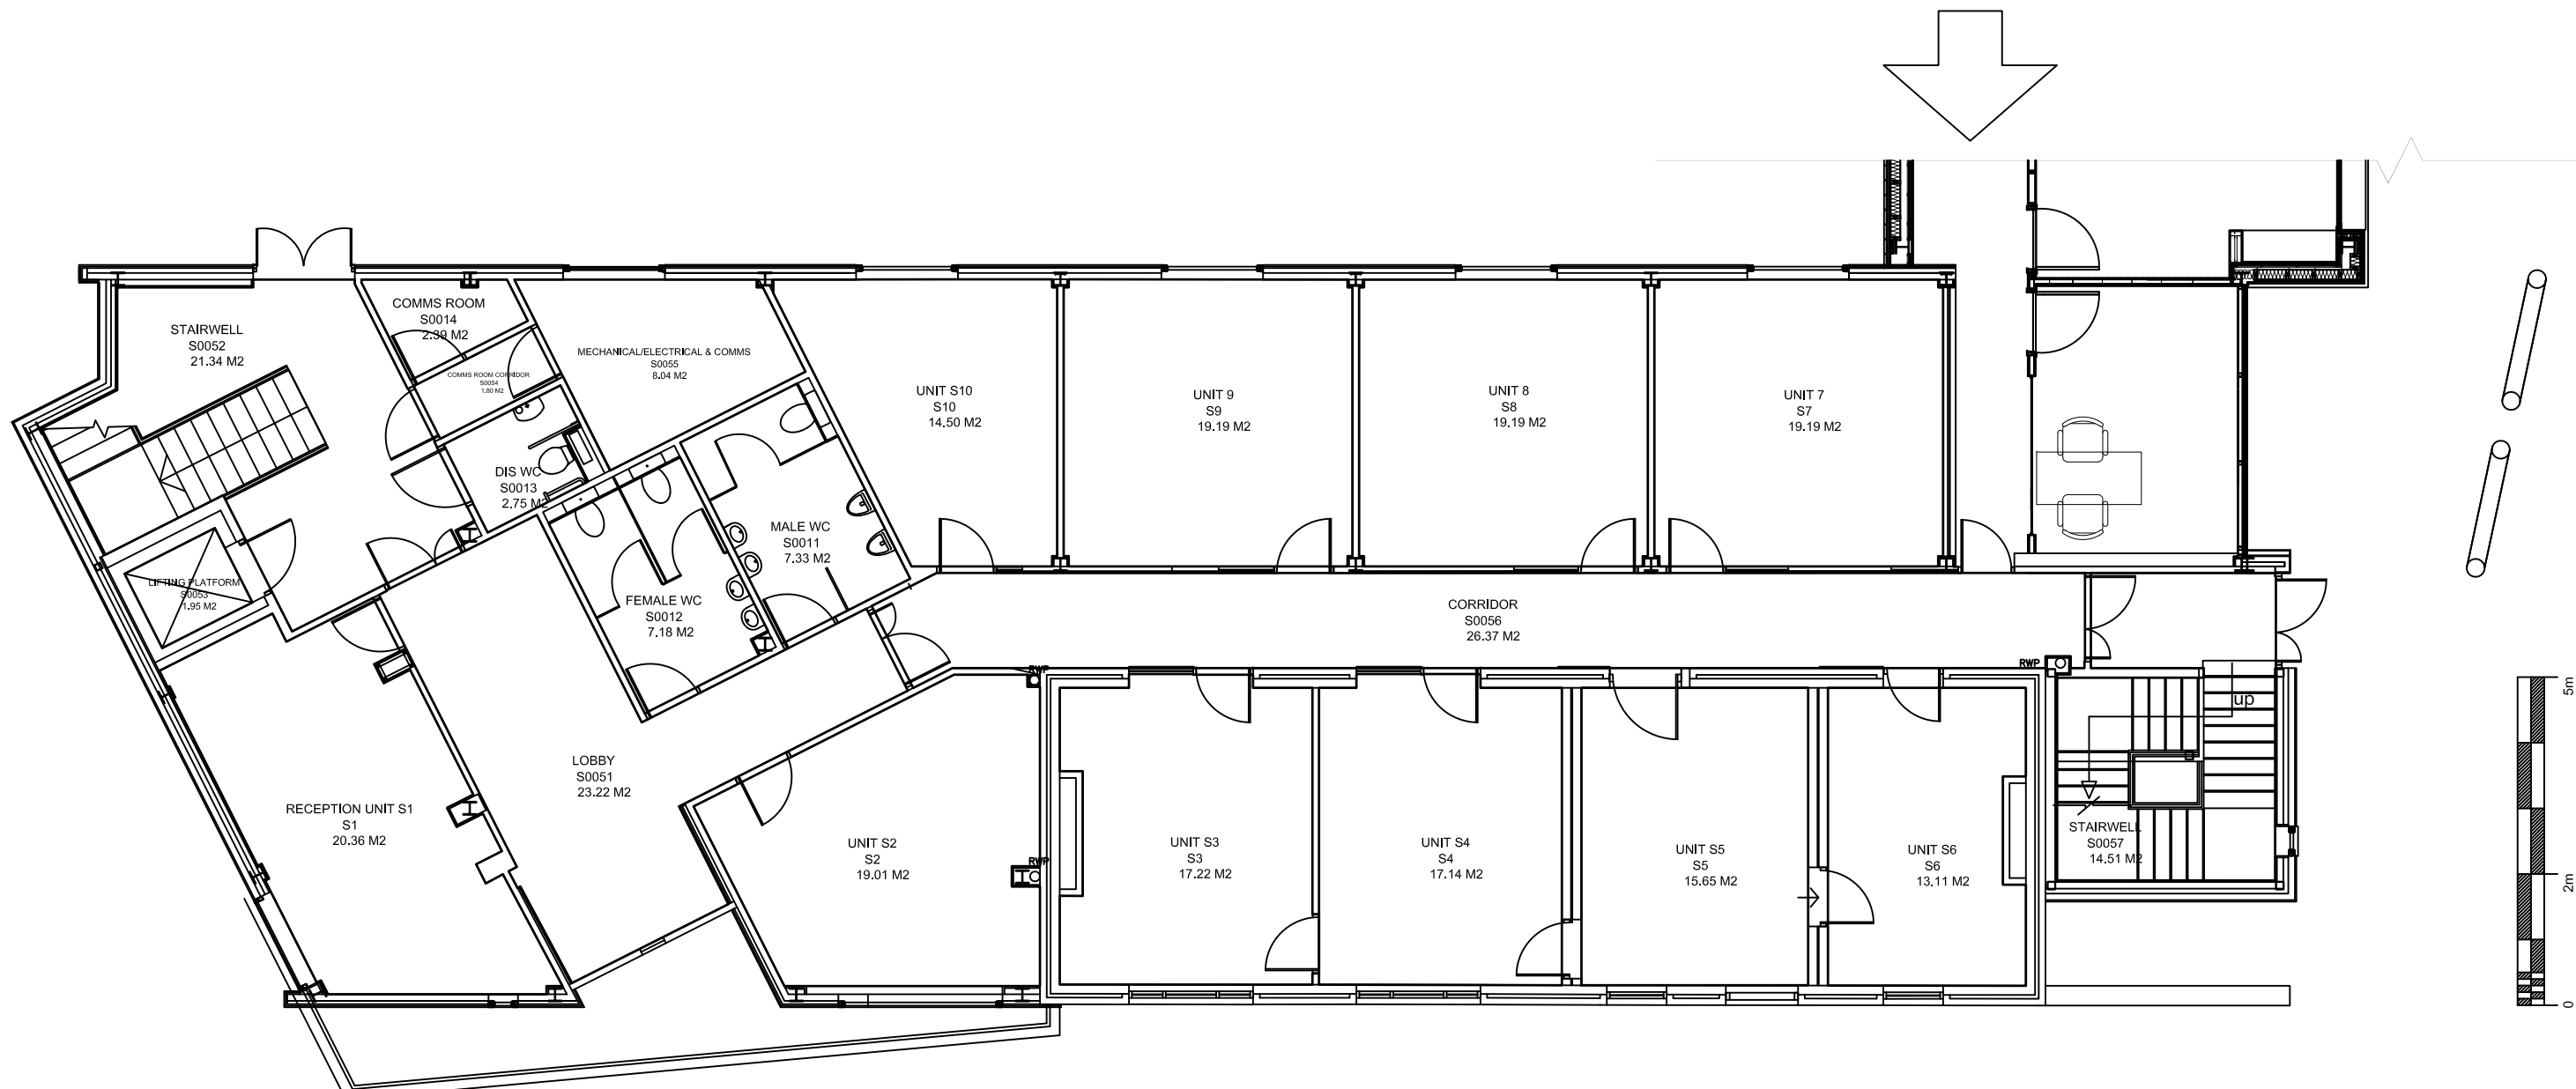

BR-017 Sparkhouse Studios Phase 1 Room Schedule						
PRN	Room Name	Room Number	Area	GIA/GEA/NIA/NET	Floor	Department Faculty/Service
BR-017	Comms room Corridor	S0054	1.80 M2	Balance Space	G	---
BR-017	Corridor	S0056	26.37 M2	Balance Space	G	---
BR-017	Dis WC	S0013	2.75 M2	Balance Space	G	---
BR-017	Female WC	S0012	7.18 M2	Balance Space	G	---
BR-017	GEA	---	337.08 M2	GEA Space	G	---
BR-017	GIA	---	315.30 M2	GIA Space	G	---
BR-017	Lifting Platform	S0053	1.95 M2	Balance Space	G	---
BR-017	Lobby	S0051	23.22 M2	Balance Space	G	---
BR-017	Male WC	S0011	7.33 M2	Balance Space	G	---
BR-017	Mechanical/Electrical & Comms	S0055	8.04 M2	Balance Space	G	---
BR-017	RECEPTION UNIT S1	S1	20.36 M2	NIA Space	G	---
BR-017	STORE	S0014	2.39 M2	NIA Space	G	---
BR-017	Stairwell	S0057	14.51 M2	Balance Space	G	---
BR-017	Stairwell	S0052	21.34 M2	Balance Space	G	---
BR-017	UNIT S5	S5	15.65 M2	NIA Space	G	---
BR-017	Unit 7	S7	19.19 M2	NIA Space	G	---
BR-017	Unit 8	S8	19.19 M2	NIA Space	G	---
BR-017	Unit 9	S9	19.19 M2	NIA Space	G	---
BR-017	Unit S10	S10	14.50 M2	NIA Space	G	---
BR-017	Unit S2	S2	19.01 M2	NIA Space	G	---
BR-017	Unit S3	S3	17.22 M2	NIA Space	G	---
BR-017	Unit S4	S4	17.14 M2	NIA Space	G	---
BR-017	Unit S6	S6	13.11 M2	NIA Space	G	---

1000 Ground Floor Plan
1:100 @ A3

Rev	Description	Date	Drwn

ESTATES AND COMMERCIAL FACILITIES
BRAYFORD POOL
LINCOLN, LN6 7TS
TEL: 01522 886749 FAX: 01522 886247

UNIVERSITY OF LINCOLN

PRN No. BR-017
PROJECT Enterprise Building South Archive
PROJECT No. N/A
DWG TITLE Ground Floor Plan
DWG No. 1000 REV *

DRWN BY JT CHECKED BY
SCALE A1 @ 1:50 DATE 23.10.14