
 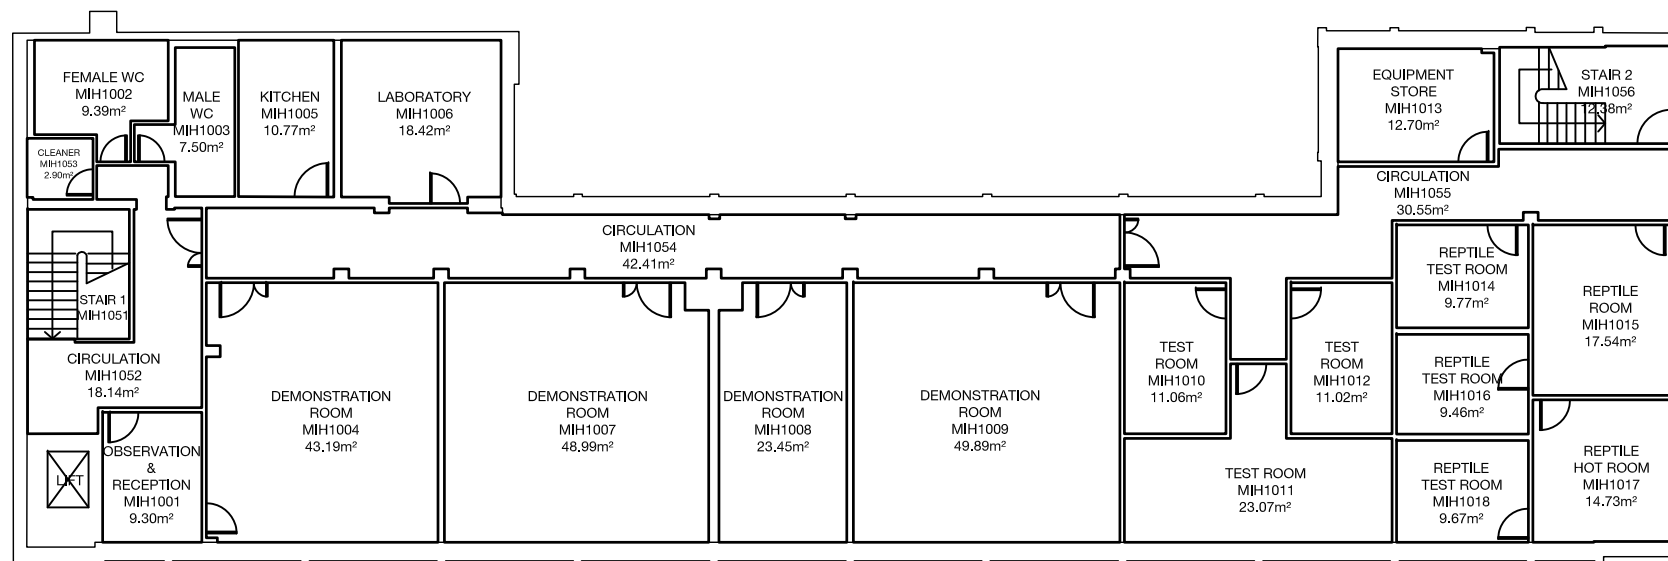
 


NOTES
 CONTRACTOR TO CHECK ALL DIMENSIONS ON SITE
 DO NOT SCALE



1010

First Floor Plan

1:200 @ A3

Rev	Description	Date	Drwn



ESTATES AND
 COMMERCIAL FACILITIES
 BRAYFORD POOL
 LINCOLN LN6 7TS
 TEL: 01522 886749 FAX: 01522 886247

PRN No. **BR-091**

PROJECT **Minster House Archive**

PROJECT No. **N/A**

DWG TITLE **First Floor Plan**

DWG No. **1010** REV *****

DRWN BY **JT** CHECKED BY

SCALE A1 @ **1:100** DATE **04.09.2014**