 




NOTES
CONTRACTOR TO CHECK ALL DIMENSIONS ON SITE
DO NOT SCALE

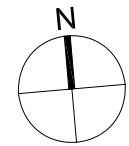

BR-015 Village Hall Room Schedule							
PRN	Room Name	Room Number	Area	GA/GEA/NA/NET	Floor	Department	Faculty/Service
BR-015	Cleaners Cup'd	VH0053	2.73 M2	Balance Space	G	---	---
BR-015	Corridor	VH0058	21.30 M2	Balance Space	G	---	---
BR-015	Corridor	VH0062	25.75 M2	Balance Space	G	---	---
BR-015	Dis. WC	VH0055	3.42 M2	Balance Space	G	---	---
BR-015	Female WC	VH0054	9.33 M2	Balance Space	G	---	---
BR-015	GEA	---	362.47 M2	GEA Space	G	---	---
BR-015	GIA	---	335.12 M2	GIA Space	G	---	---
BR-015	Lift	VH0056	2.79 M2	Balance Space	G	---	---
BR-015	Male WC	VH0057	9.74 M2	Balance Space	G	---	---
BR-015	Riser	VH0065	0.90 M2	Balance Space	G	---	---
BR-015	Riser	VH0063	0.90 M2	Balance Space	G	---	---
BR-015	Riser	VH0061	0.90 M2	Balance Space	G	---	---
BR-015	Riser	VH0052	1.37 M2	Balance Space	G	---	---
BR-015	Riser	VH0060	0.90 M2	Balance Space	G	---	---
BR-015	Riser	VH0059	0.90 M2	Balance Space	G	---	---
BR-015	Riser	VH0064	0.90 M2	Balance Space	G	---	---
BR-015	Seminar Room	VH0004	41.52 M2	NIA Space	G	---	---
BR-015	Seminar Room	VH0002	33.12 M2	NIA Space	G	---	---
BR-015	Seminar Room	VH0001	33.93 M2	NIA Space	G	---	---
BR-015	Seminar Room	VH0003	33.10 M2	NIA Space	G	---	---
BR-015	Seminar Room	VH0005	42.17 M2	NIA Space	G	---	---
BR-015	Stairs	VH0051	30.93 M2	Balance Space	G	---	---
BR-015	Stairs	VH0066	18.11 M2	Balance Space	G	---	---

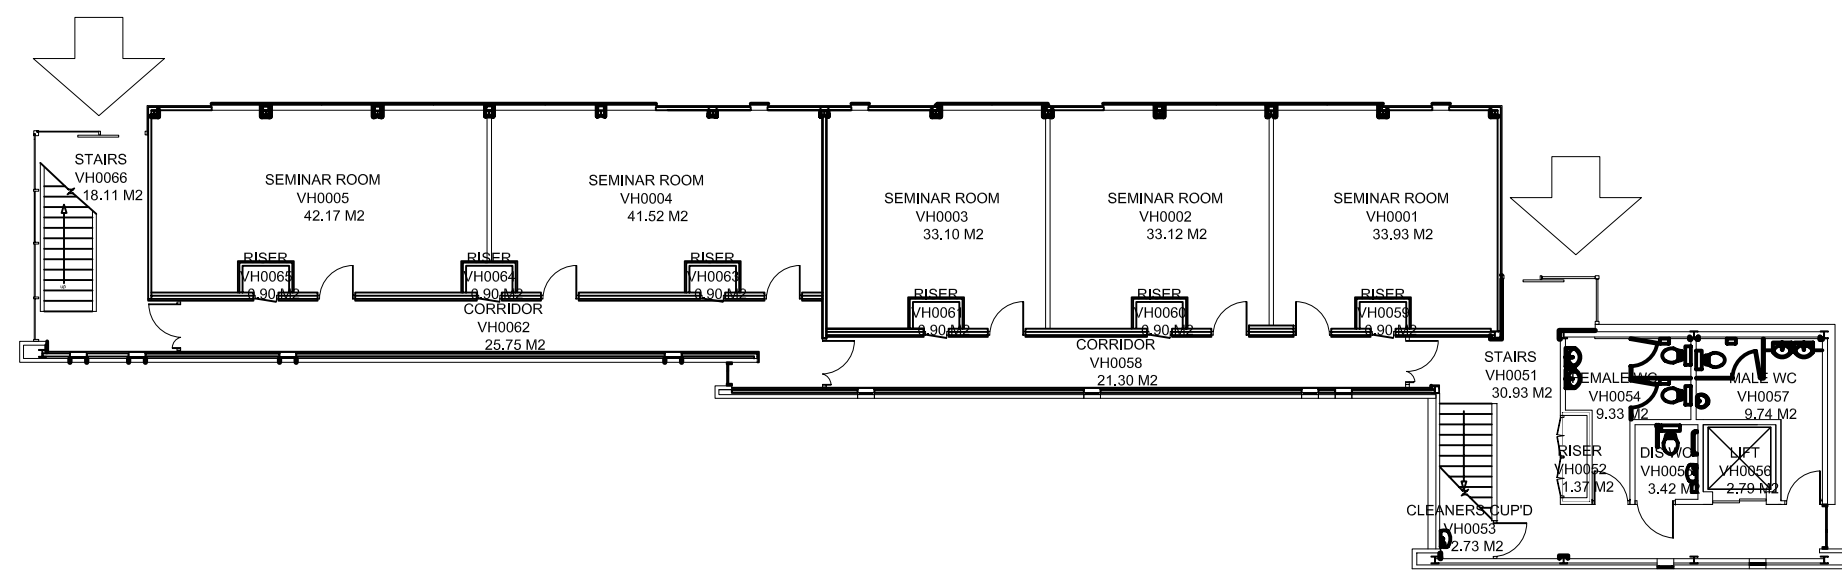

1000 Ground Floor Plan
1:200 at A3

Rev	Description	Date	Drwn



ESTATES AND
COMMERCIAL FACILITIES
BRAYFORD POOL
LINCOLN LN6 7TS
TEL: 01522 886749 FAX: 01522 886247

PRN No.	BR-015
PROJECT	Village Hall Archive
PROJECT No.	N/A
DWG TITLE	Ground Floor Plan
DWG No.	1000
REV	*
DRWN BY	JB
CHECKED BY	
SCALE A1@ 1:100	DATE 23.09.13