
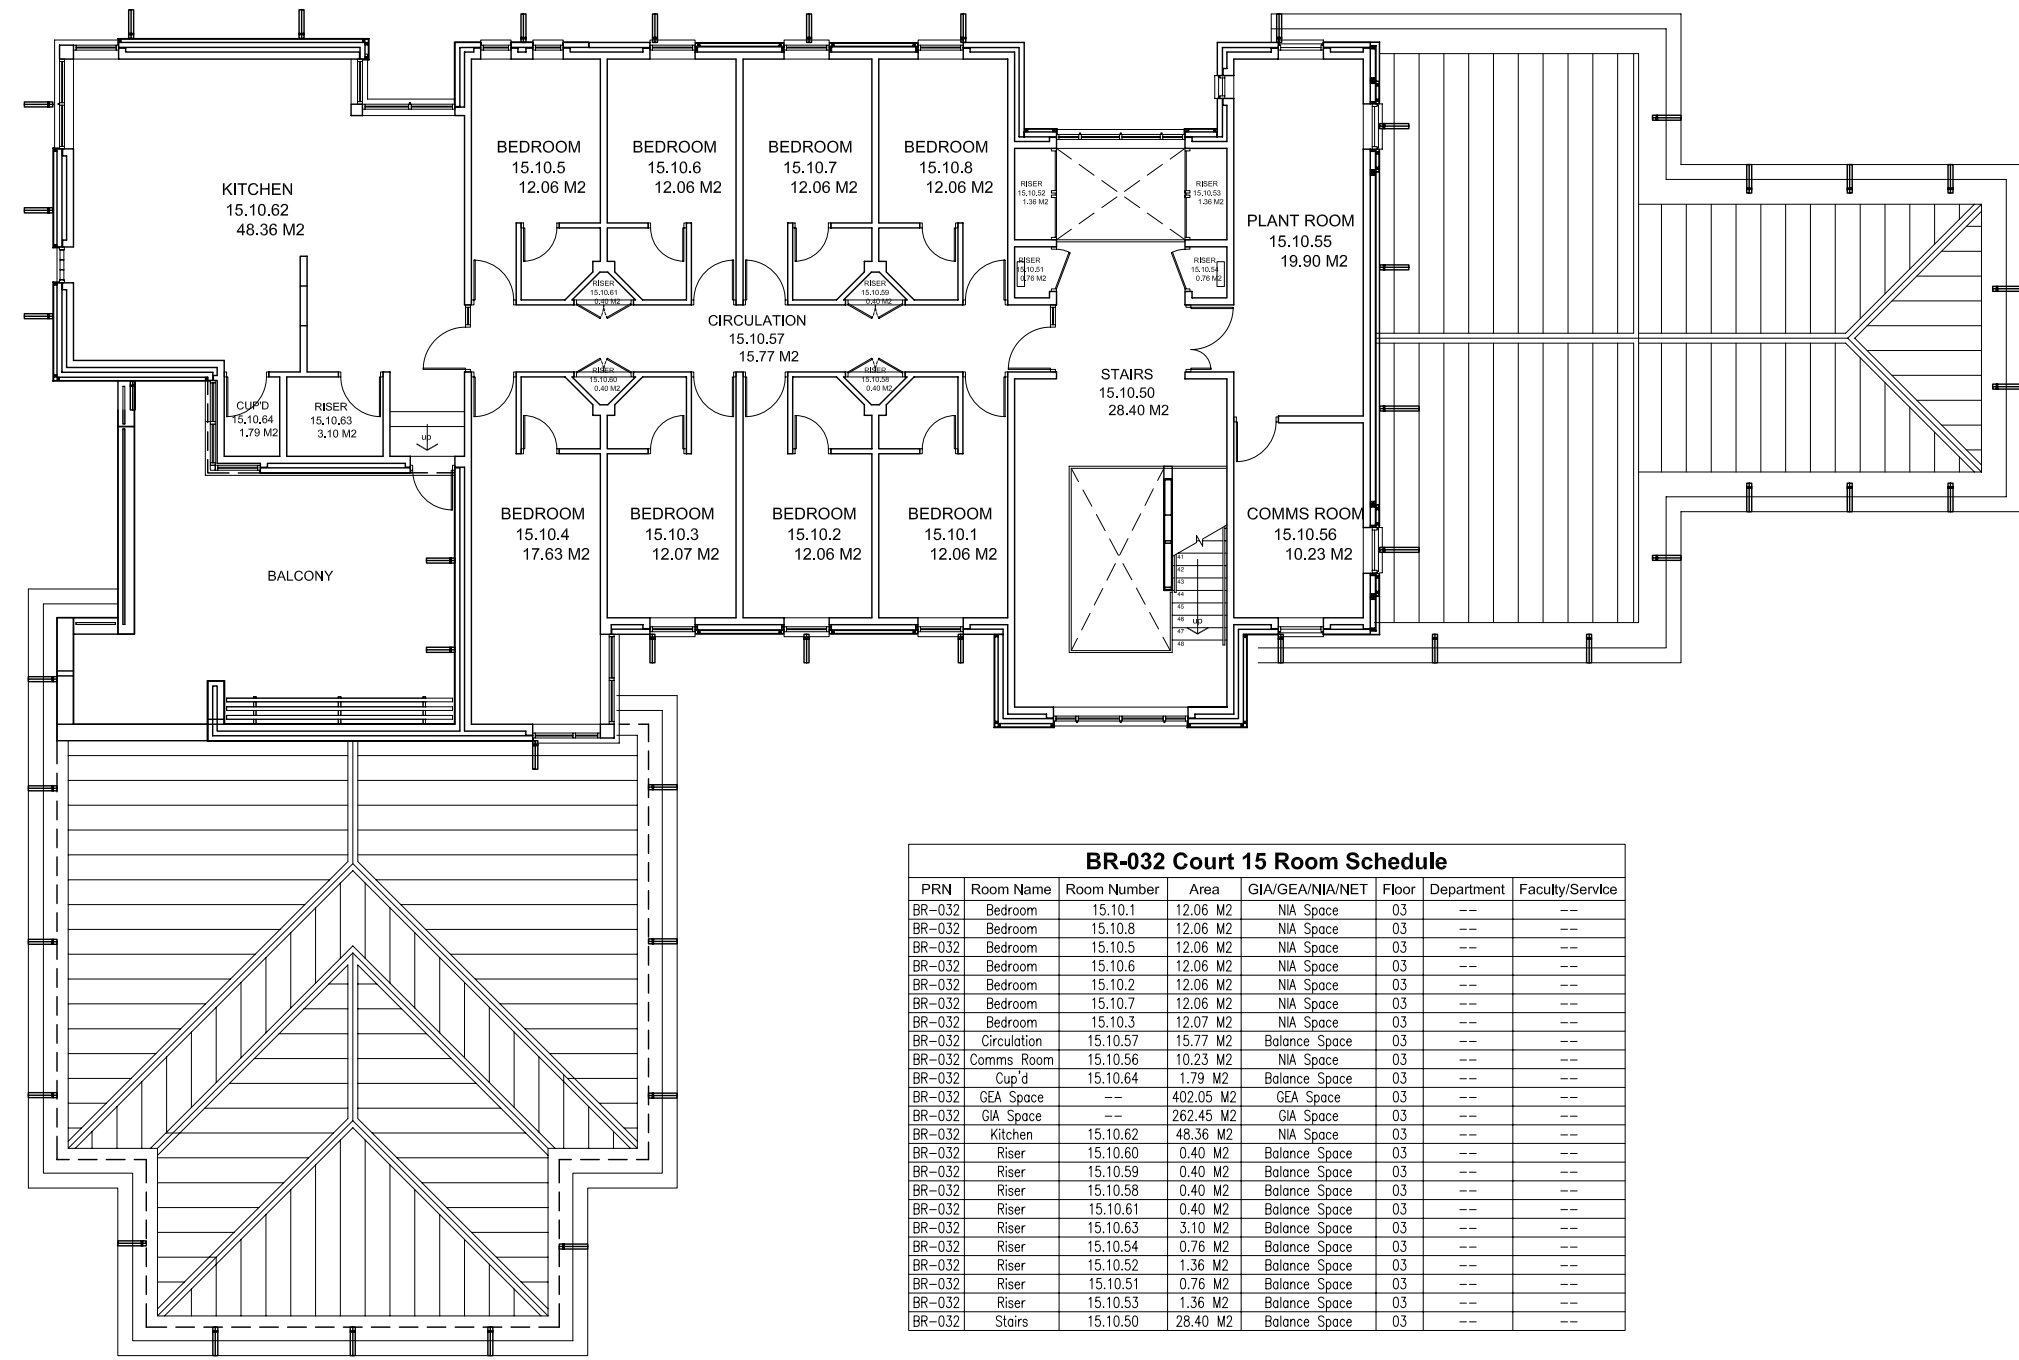


NOTES
 CONTRACTOR TO CHECK ALL DIMENSIONS ON SITE
 DO NOT SCALE

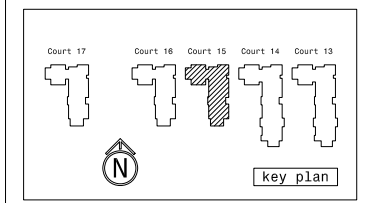

BR-032 Court 15 Room Schedule

PRN	Room Name	Room Number	Area	GIA/GEA/NIA/NET	Floor	Department	Faculty/Service
BR-032	Bedroom	15.10.1	12.06 M2	NIA Space	03	--	--
BR-032	Bedroom	15.10.8	12.06 M2	NIA Space	03	--	--
BR-032	Bedroom	15.10.5	12.06 M2	NIA Space	03	--	--
BR-032	Bedroom	15.10.6	12.06 M2	NIA Space	03	--	--
BR-032	Bedroom	15.10.2	12.06 M2	NIA Space	03	--	--
BR-032	Bedroom	15.10.7	12.06 M2	NIA Space	03	--	--
BR-032	Bedroom	15.10.3	12.07 M2	NIA Space	03	--	--
BR-032	Circulation	15.10.57	15.77 M2	Balance Space	03	--	--
BR-032	Comms Room	15.10.56	10.23 M2	NIA Space	03	--	--
BR-032	Cup'd	15.10.64	1.79 M2	Balance Space	03	--	--
BR-032	GEA Space	--	402.05 M2	GEA Space	03	--	--
BR-032	GIA Space	--	262.45 M2	GIA Space	03	--	--
BR-032	Kitchen	15.10.62	48.36 M2	NIA Space	03	--	--
BR-032	Riser	15.10.60	0.40 M2	Balance Space	03	--	--
BR-032	Riser	15.10.59	0.40 M2	Balance Space	03	--	--
BR-032	Riser	15.10.58	0.40 M2	Balance Space	03	--	--
BR-032	Riser	15.10.61	0.40 M2	Balance Space	03	--	--
BR-032	Riser	15.10.63	3.10 M2	Balance Space	03	--	--
BR-032	Riser	15.10.54	0.76 M2	Balance Space	03	--	--
BR-032	Riser	15.10.52	1.36 M2	Balance Space	03	--	--
BR-032	Riser	15.10.51	0.76 M2	Balance Space	03	--	--
BR-032	Riser	15.10.53	1.36 M2	Balance Space	03	--	--
BR-032	Stairs	15.10.50	28.40 M2	Balance Space	03	--	--

1030

Third Floor Plan
 1:150 @ A3

Rev	Description	Date	Drwn

ESTATES AND FACILITIES
 SERVICE BUILDING
 BRAYFORD POOL
 LINCOLN, LN6 7TS
 TEL: 01522 886749 FAX: 01522 886247

PRN No.	BR-032
PROJECT	Court 15 Archive
PROJECT No.	N/A
DWG TITLE	Third Floor Plan
DWG No.	1030
REV	*
DRWN BY.	JB
CHECKED BY.	
SCALE.	A1 @ 1:75
DATE	23/06/11