
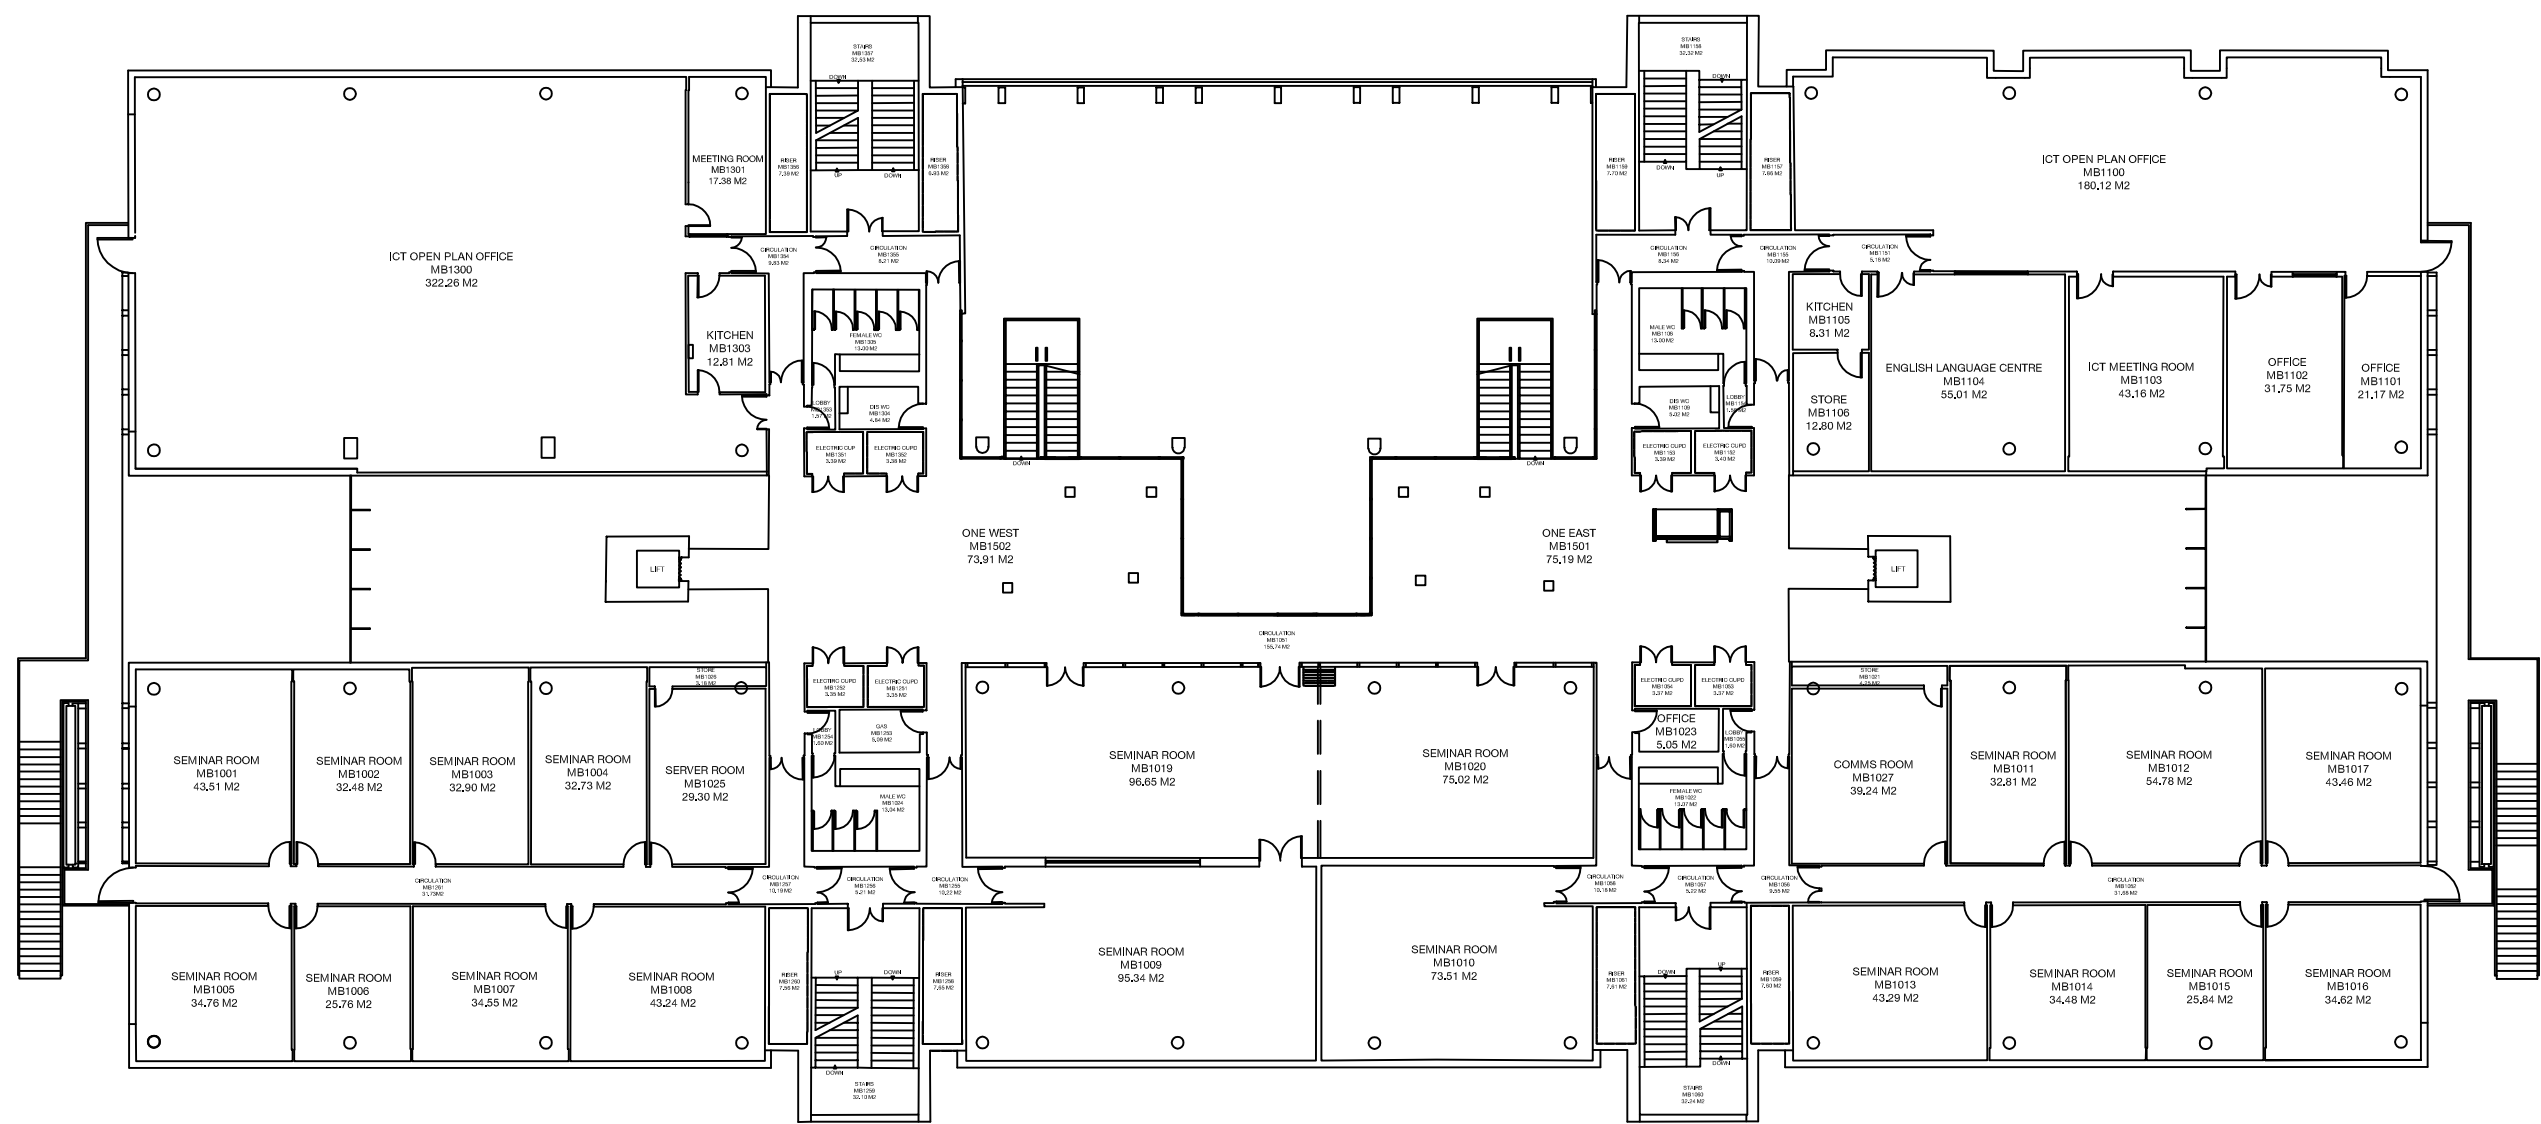


NOTES
CONTRACTOR TO CHECK ALL DIMENSIONS ON SITE
DO NOT SCALE

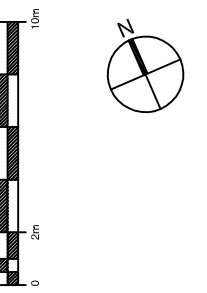

1010 First Floor Plan
1:100 @ A0

Rev	Description	Date	Drawn

ESTATES AND COMMERCIAL FACILITIES
UNIVERSITY OF LINCOLN
BRAYFORD POOL, LINCOLN, LIN LN7C
TEL: 01509 886149 FAX: 01509 886147

PRJ No. BR-001
PROJECT Mierva Building Archive
PROJECT No. N/A
DWG TITLE First Floor Plan
DWG No. 1010 REV *

DRAWN BY JT CHECKED BY
SCALE A0@ 1:100 DATE 04.04.16