
 


NOTES  
 CONTRACTOR TO CHECK ALL DIMENSIONS ON SITE  
 DO NOT SCALE

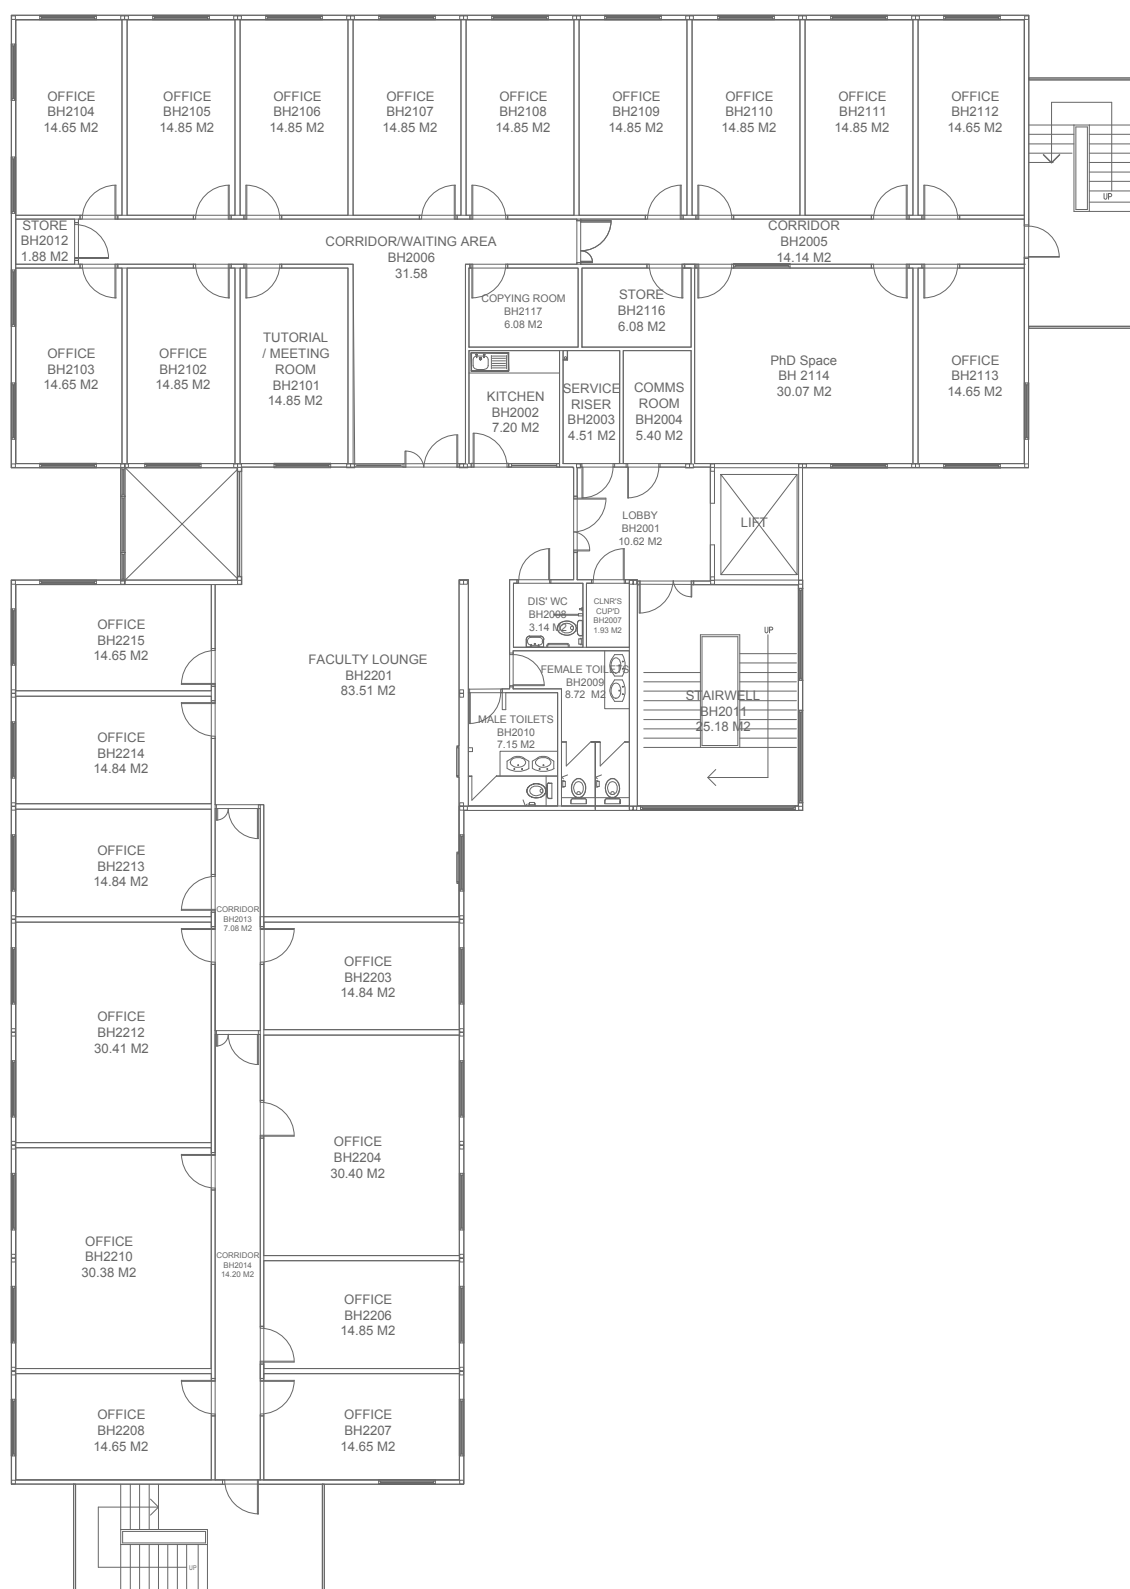

Rev	Description	Date	Drwn
A	Updated after summer works	08.01.17	RN



ESTATES AND  
 COMMERCIAL FACILITIES  
 BRAYFORD POOL  
 LINCOLN, LN6 7TS  
 TEL: 01522 886749 FAX: 01522 886247

PRN No.	BR-008
PROJECT	Bridge House Archive
PROJECT No.	N/A
DWG TITLE	Second Floor Plan
DWG No.	1020
REV	*
DRWN BY	JB
CHECKED BY	
SCALE	A1 @ 1:100
DATE	01.09.17

1020

Second Floor Plan  
 1:200 @ A3